



SECOND FLOOR PLAN

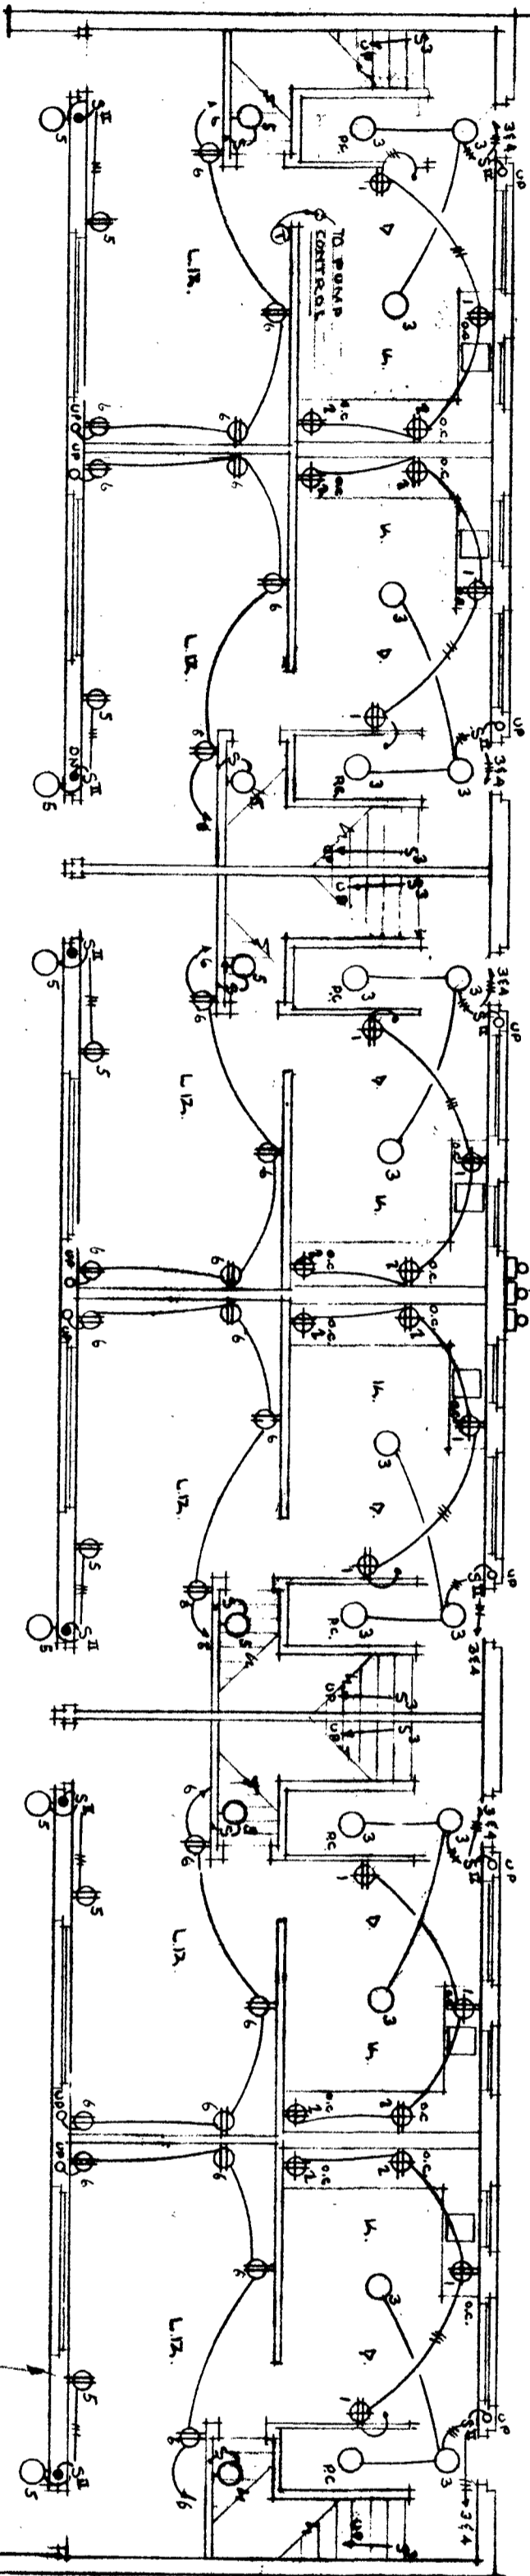

FIRST FLOOR PLAN

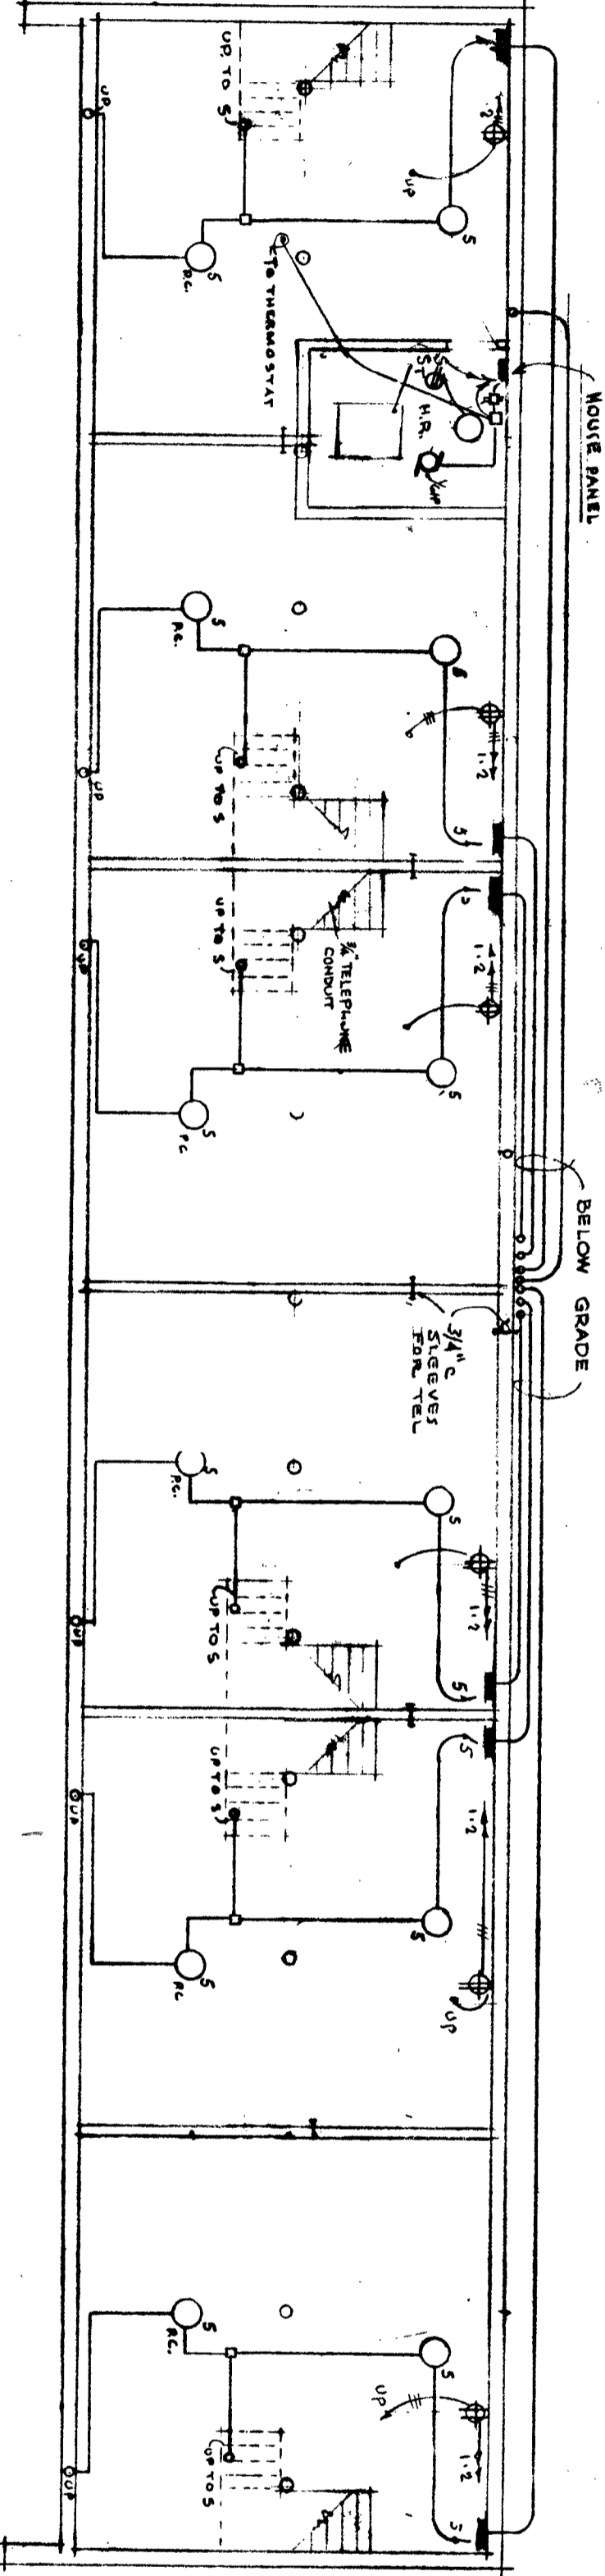


BASEMENT PLAN

3 BEDROOM UNIT

SCALE 1/8" = 1'-0"

I HEREBY CERTIFY THAT THESE PLANS FOR THE ABOVE UNIT ARE CORRECT TO THE BEST OF MY KNOWLEDGE

APPROVED AND SIGNED
 R. B. FRIZZARDO
 REGISTERED PROFESSIONAL ENGINEER
 No. 31 192

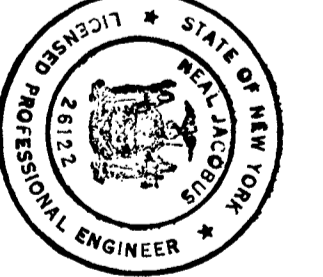

EDU. BLDG. 3 E. RM. TYPE ELECTRICAL	SCALE 1/8" = 1'-0"
100 UNITS LOW RENT HOUSING	JOB NO. 30-147
R.H.A. N.Y. 11-2 FOR THE	DATE 5-16-60
NIAGARA FALLS HOUSING AUTHORITY	DWG. NO. E-303
NIAGARA FALLS, N.Y.	
SHACKLETON AND FITZGERALD, A.I.A.	
ARCHITECTS	
1515 LOOKPORT STREET	
NIAGARA FALLS, N. Y.	
THE CONTRACTOR SHALL VERIFY ALL DIMENSIONS AT SITE BEFORE STARTING WORK	