



SECOND FLOOR PLAN

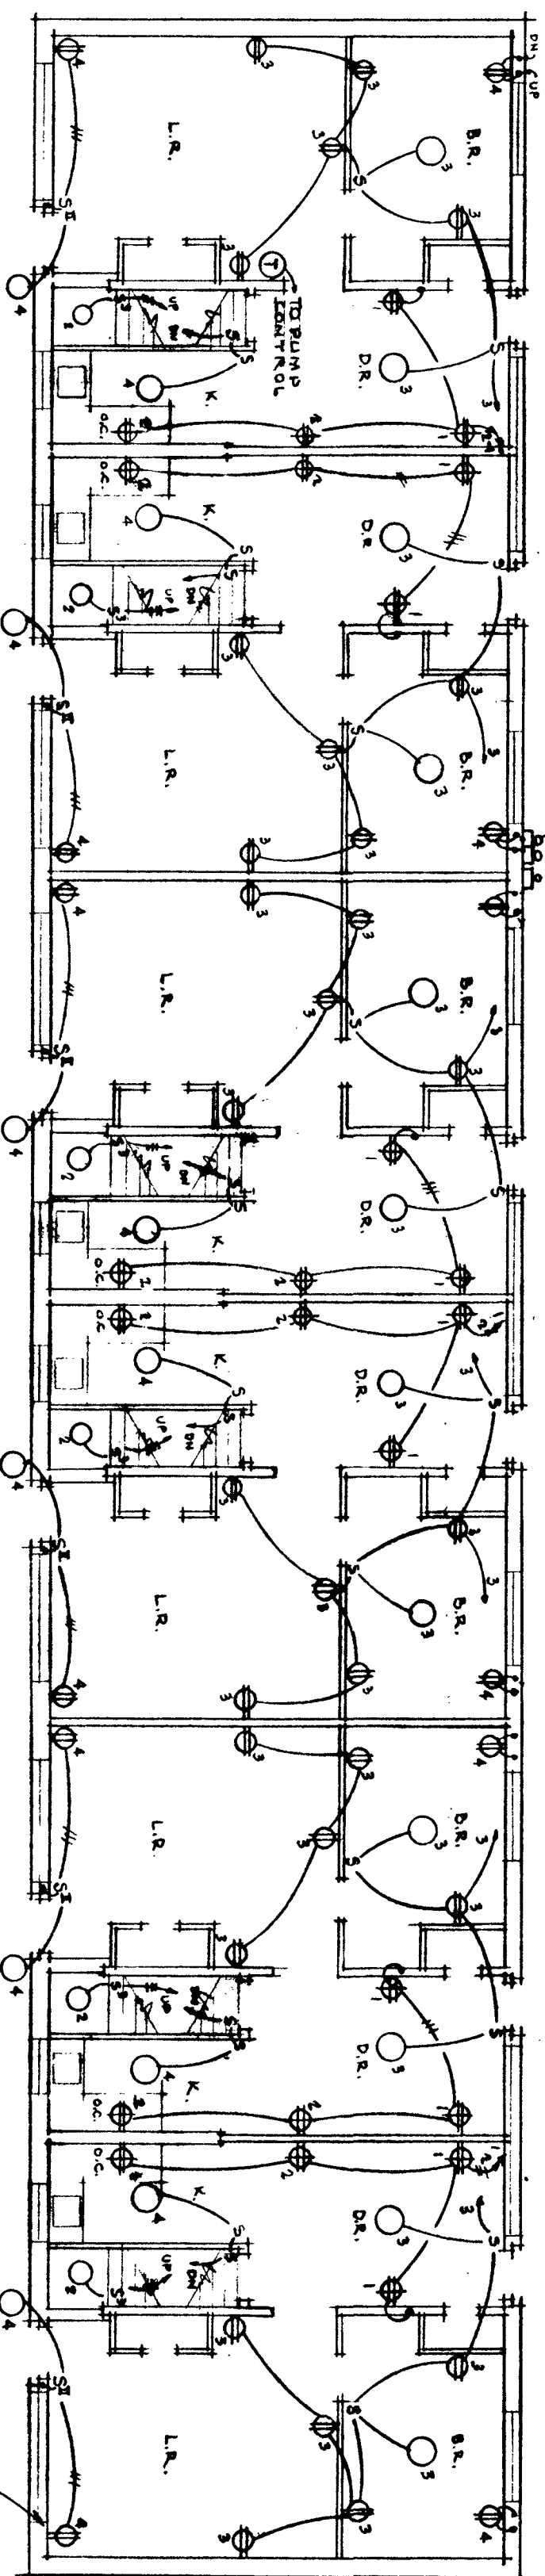

FIRST FLOOR PLAN

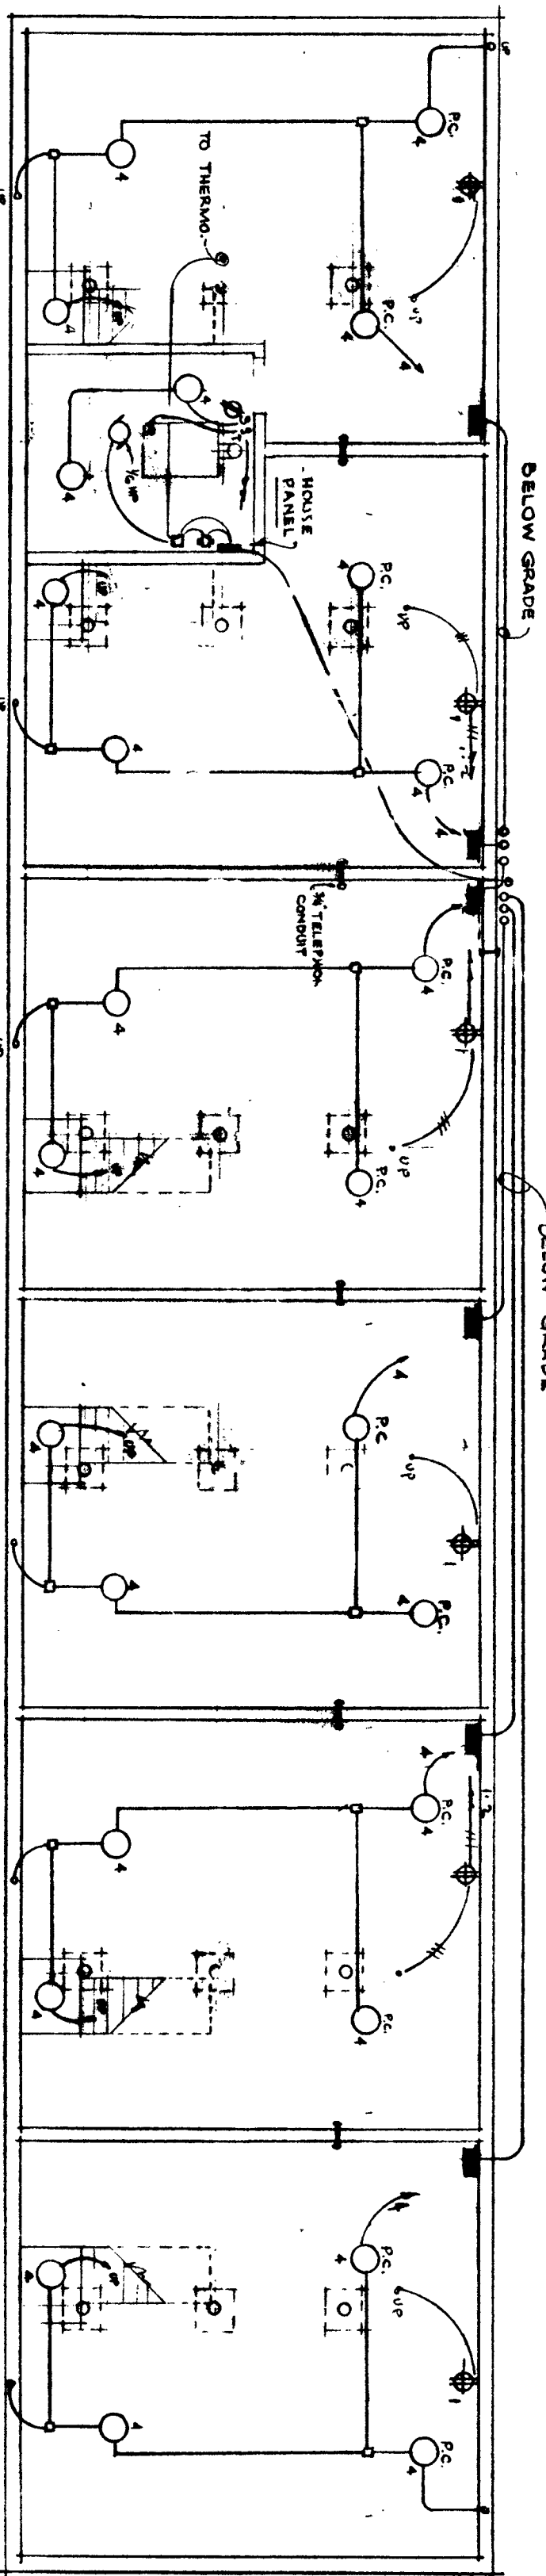


BASEMENT PLAN

4 BEDROOM UNIT

SCALE 1/8" = 1'-0"

I HEREBY CERTIFY THAT THESE PLANS FOR CONSTRUCTION AND ELECTRICAL CONNECTIONS ARE CORRECT TO THE BEST OF MY KNOWLEDGE.

James J. Fitzgerald
 MAY 31 1952

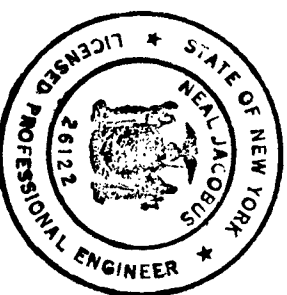

SCALE	AS NOTED
JOB NO.	50-147
DATE	5-18-50
DWG. NO.	E-304
GDO BLDG. AB. RM. TYPE, ELECTRICAL 100 UNITS LOW RENT HOUSING P.H.A. N.Y. II-2 FOR THE NIAGARA FALLS HOUSING AUTHORITY NIAGARA FALLS, N.Y. SHACKLETON AND FITZGERALD A.I.A. ARCHITECTS 1513 LOCKPORT STREET NIAGARA FALLS, N. Y.	
THE CONTRACTOR SHALL VERIFY ALL DIMENSIONS AT SITE BEFORE STARTING WORK	