



SECOND FLOOR PLAN
SCALE: 1/8" = 1'-0"

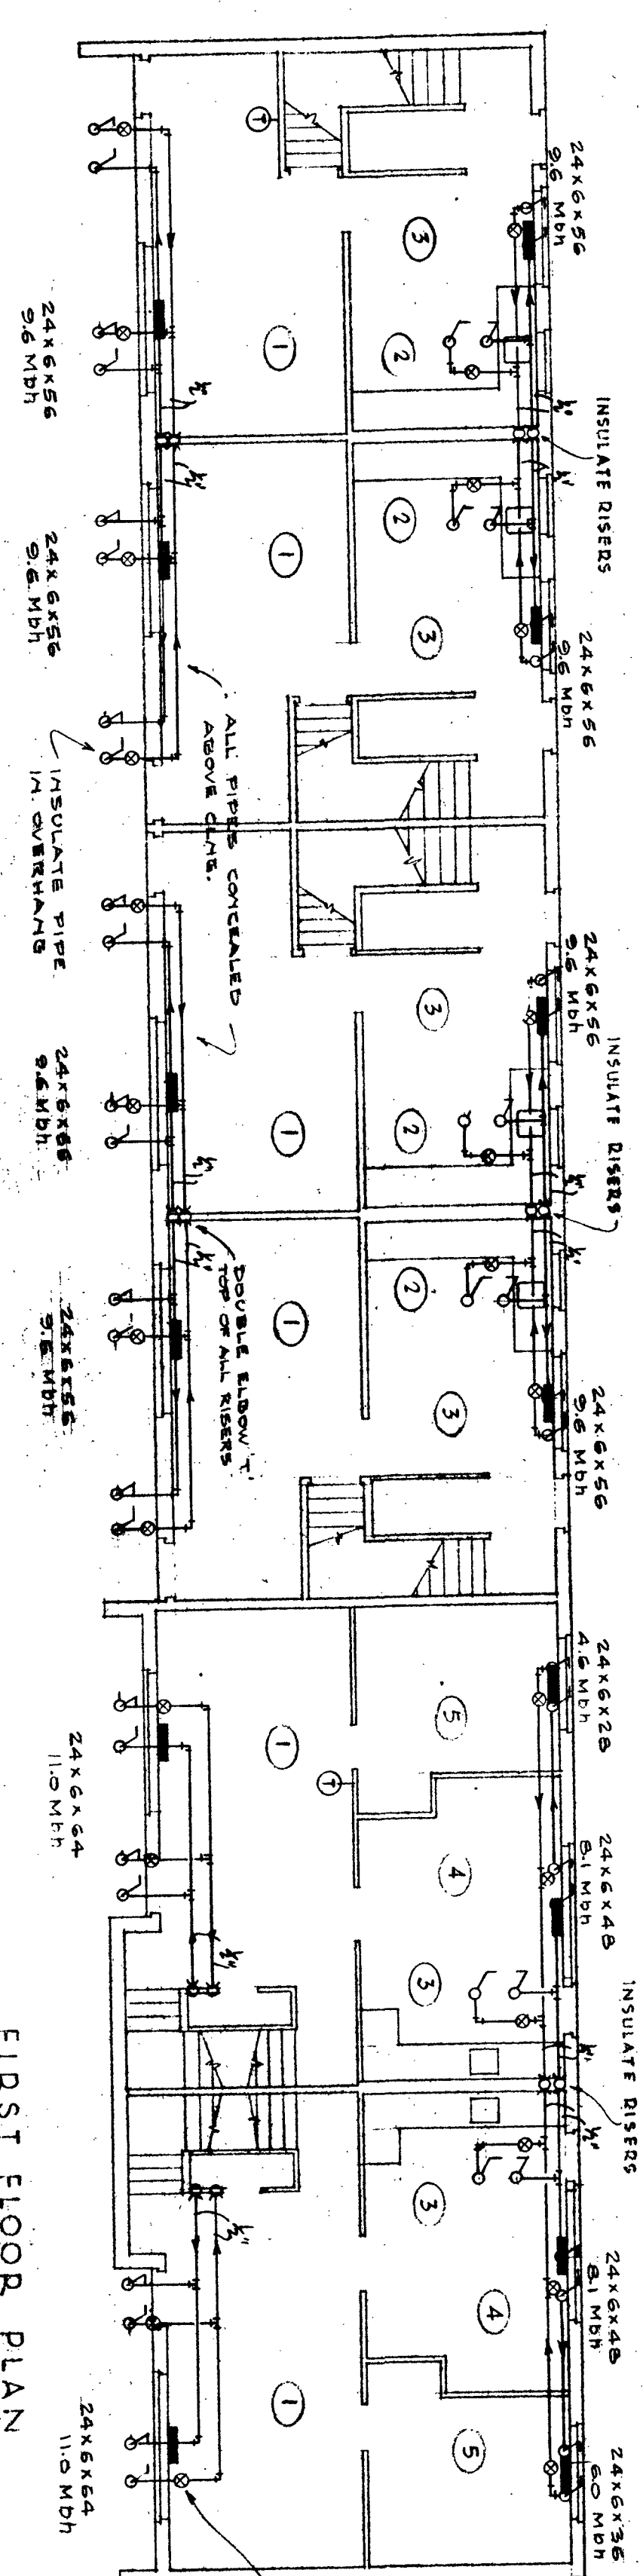


FIRST FLOOR PLAN
SCALE: 1/8" = 1'-0"

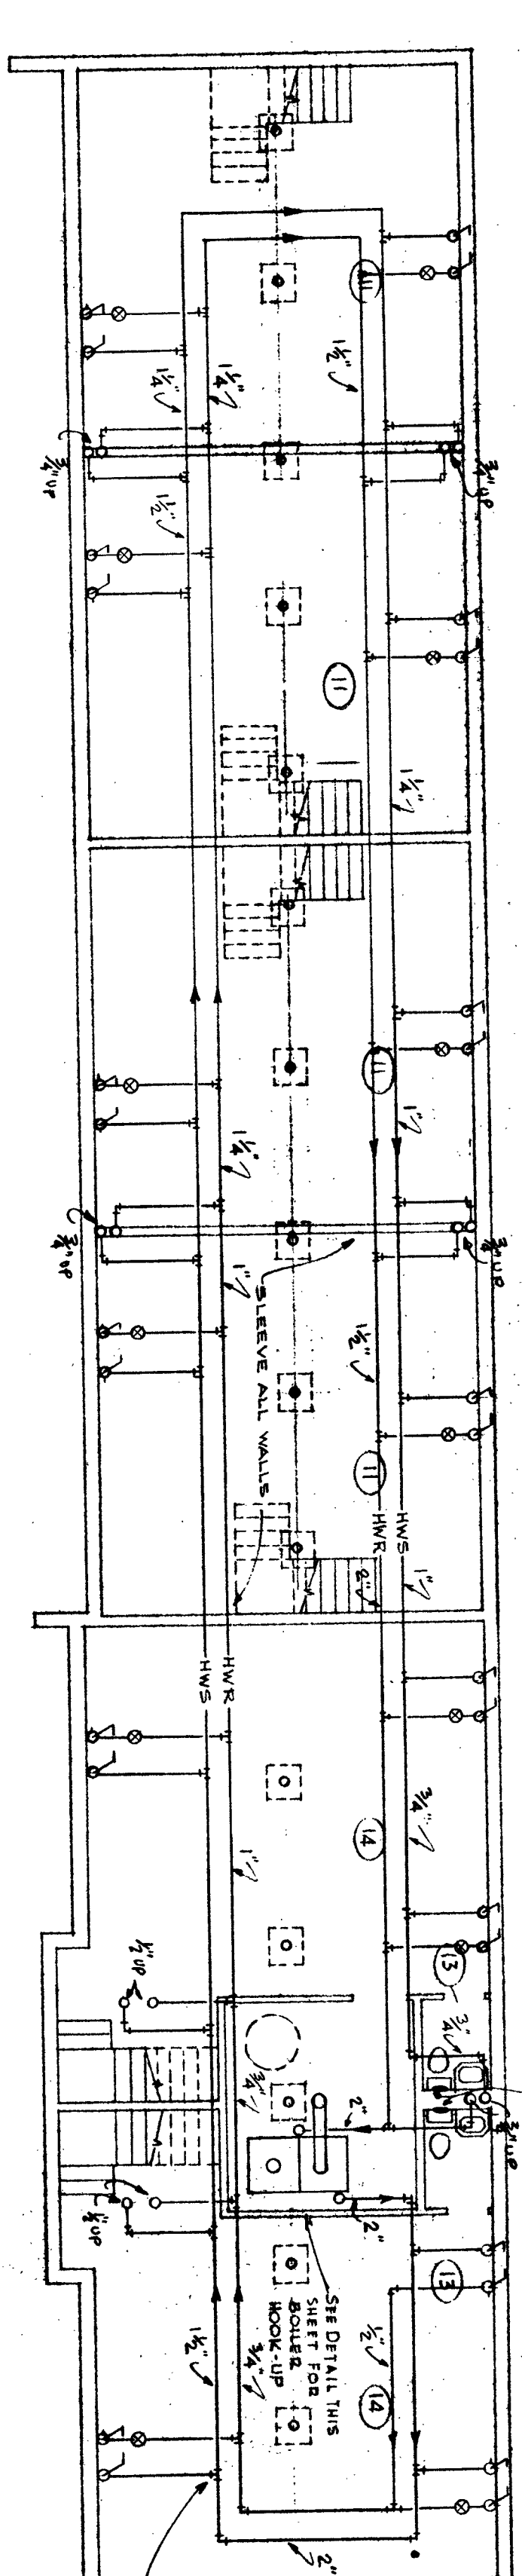


BASEMENT PLAN
SCALE: 1/8" = 1'-0"

- NOTES:
- COORDINATE WORK WITH PLUMBING CONTRACTOR & GENERAL CONTRACTOR.
 - ALL LINES TO RUN PARALLEL WITH BUILDING LINES, ESPECIALLY SPACES.
 - INSULATE RISERS AT OUTSIDE WALLS & AS SHOWN.
 - ALL TANKS ON 1/2" CURBS UNLESS NOTED OTHERWISE.

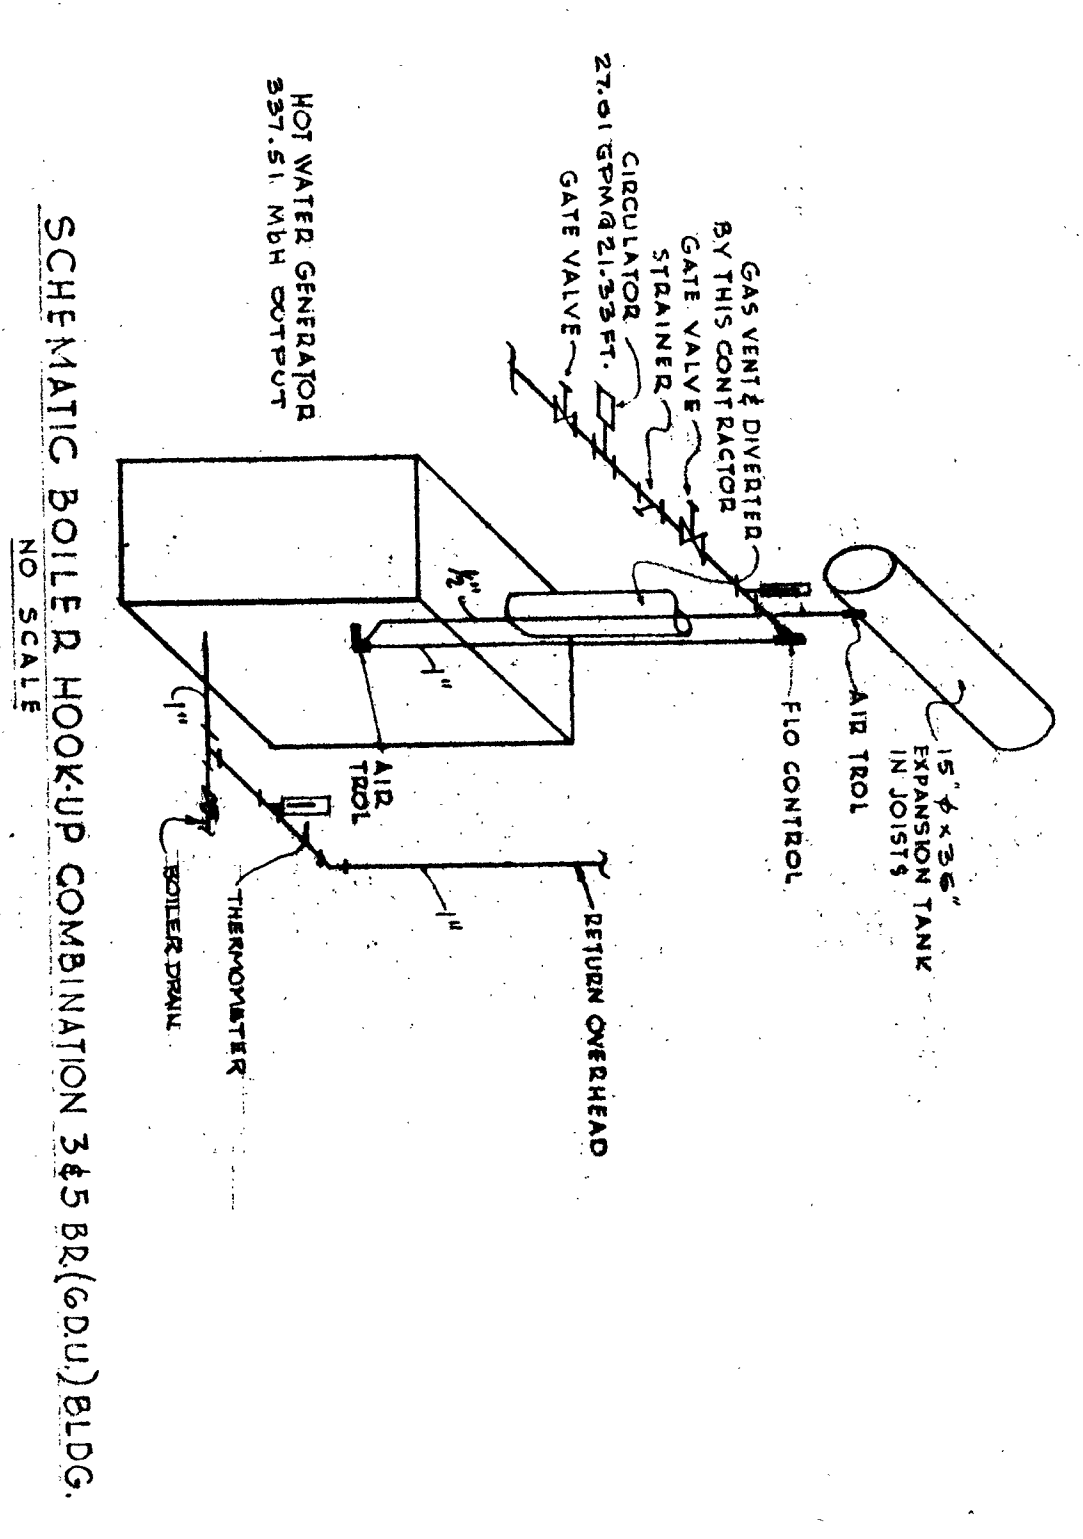

SHEMATIC BOILER HOOKUP COMBINATION 345 BR (60U) BLDG.
NO SCALE

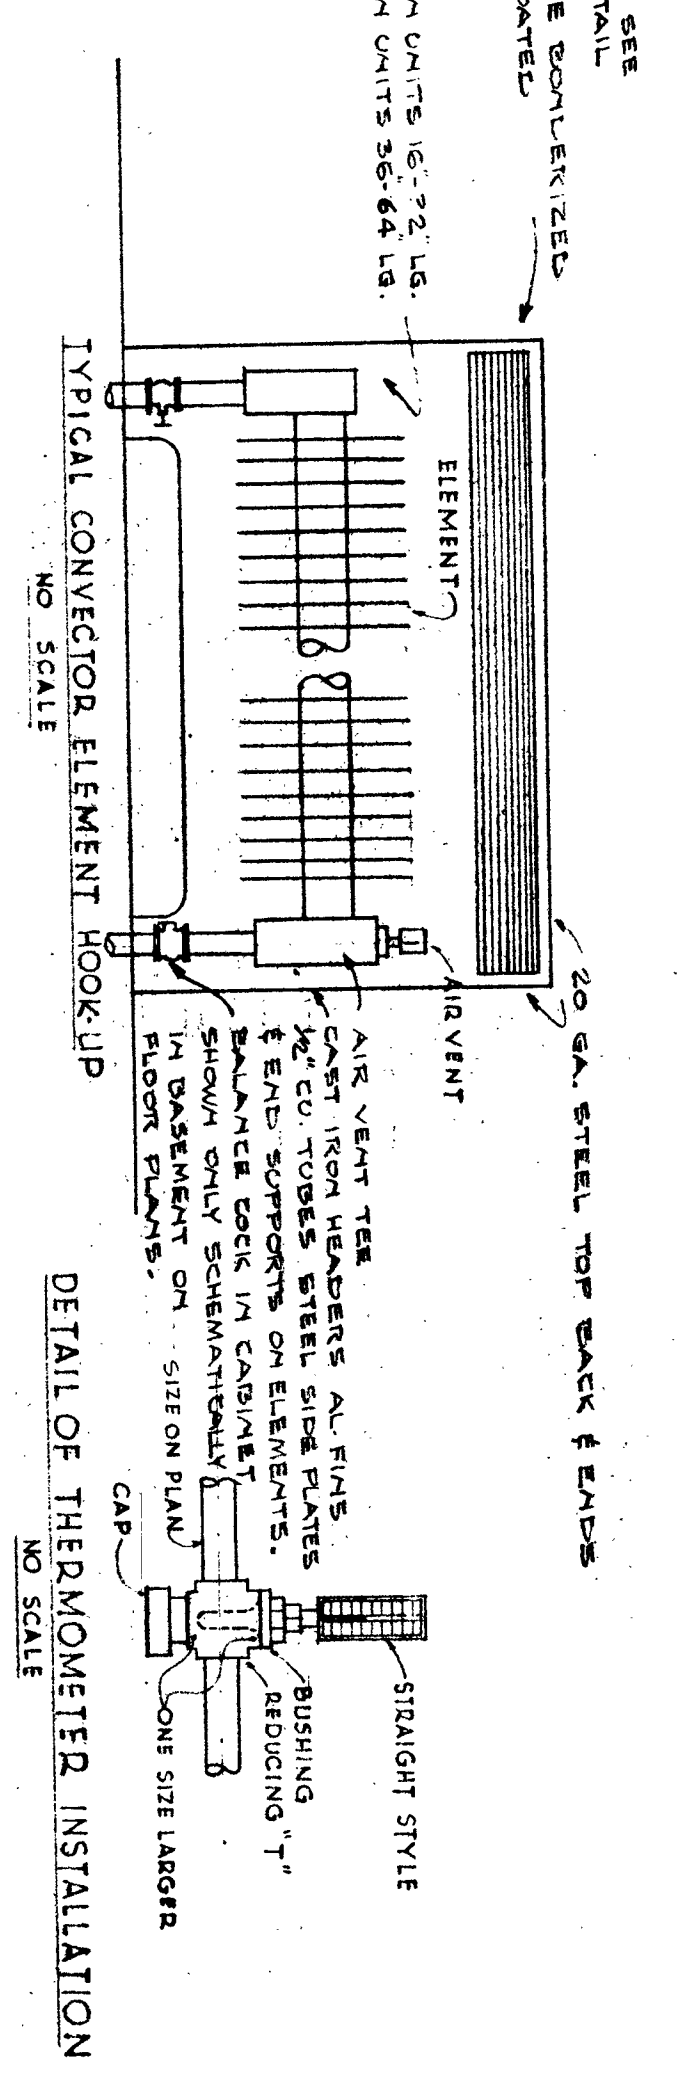

TYPICAL CONNECTOR ELEMENT HOOKUP
NO SCALE

DETAIL OF THERMOMETER INSTALLATION
NO SCALE



6 DUBLDG 345 BR COMB. MISC. DETAILS
100 UNITS LOW RENT HOUSING
R. H. A. N.Y. 11-2 FOR THE
NIAGARA FALLS HOUSING AUTHORITY
NIAGARA FALLS, N.Y.
SHACKLETON AND FITZGERALD, A.I.A.
ARCHITECTS
1815 LOCKPORT STREET
NIAGARA FALLS, N.Y.

SCALE 1/8" = 1'-0"
JOB NO. 59-147
DATE 5-16-60
DWG NO. H-106

THE CONTRACTOR SHALL VERIFY ALL DIMENSIONS AT SITE BEFORE STARTING WORK