




FIRST FLOOR PLAN
SCALE: 1/8" = 1'-0"

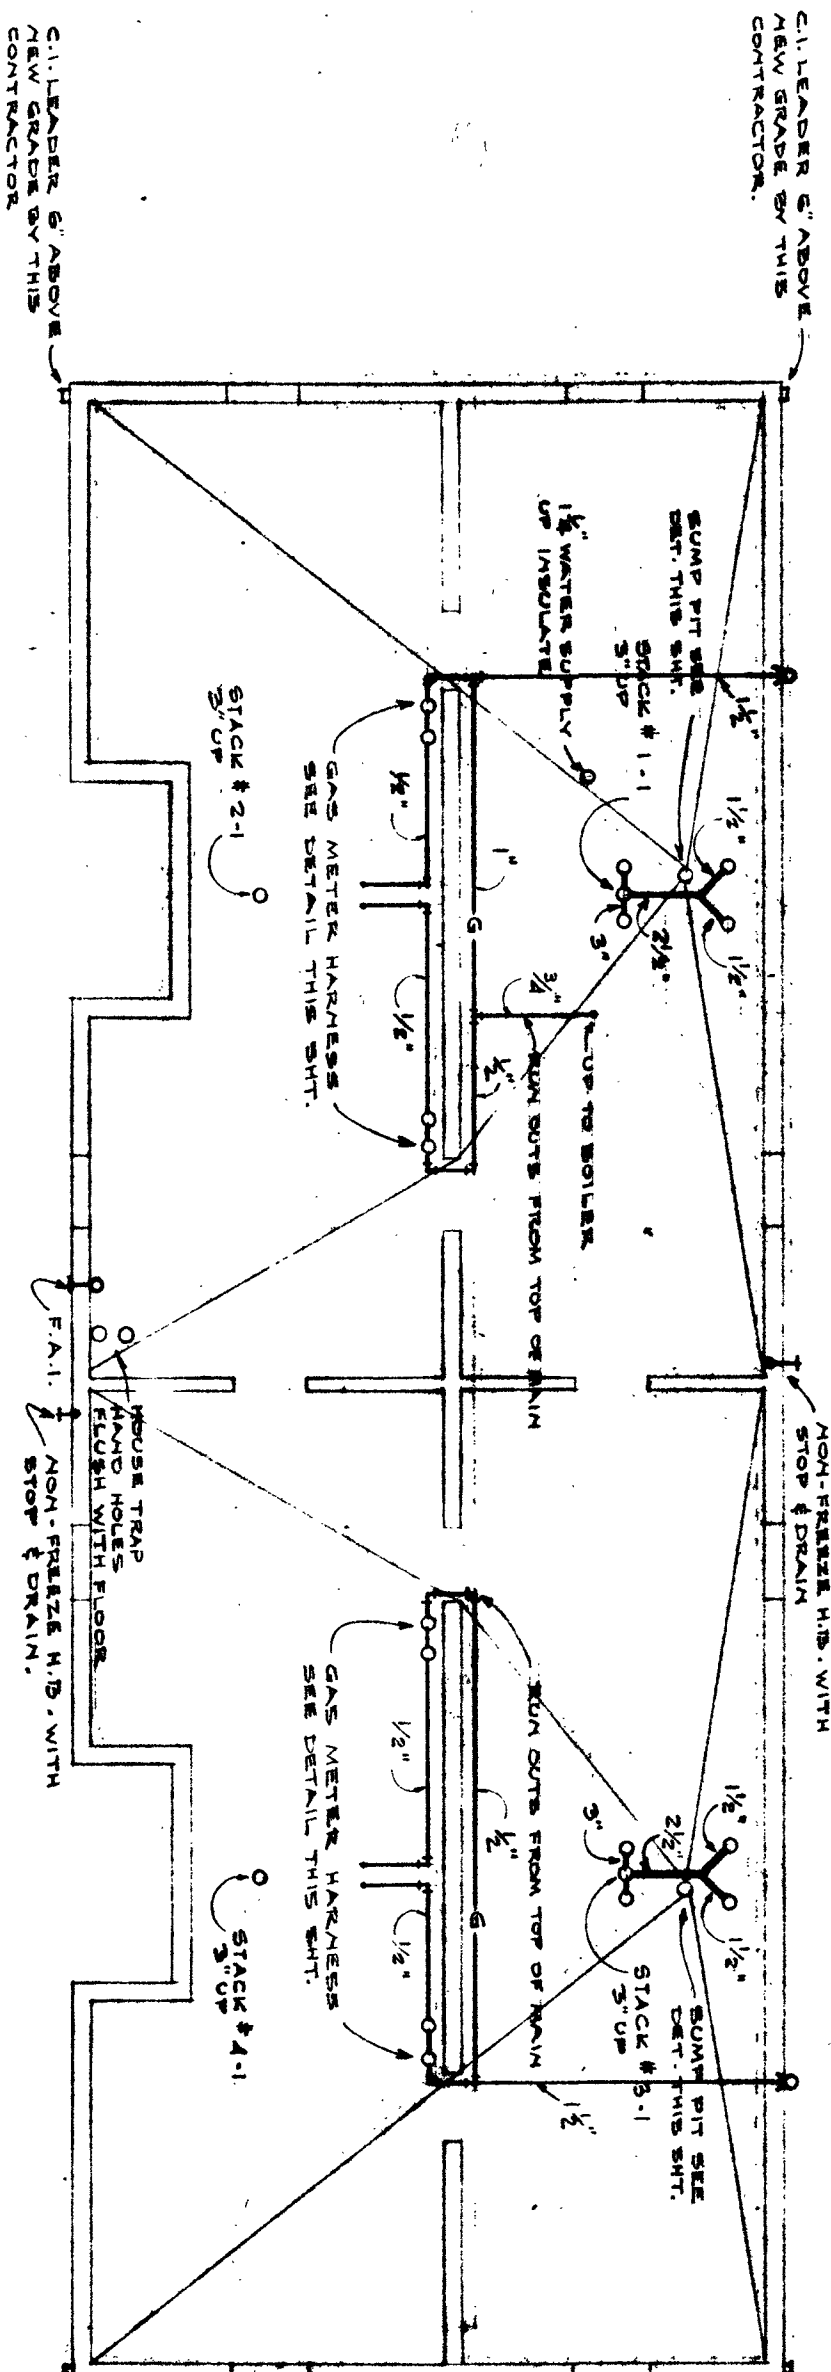


CRAWL SPACE
SCALE: 1/8" = 1'-0"

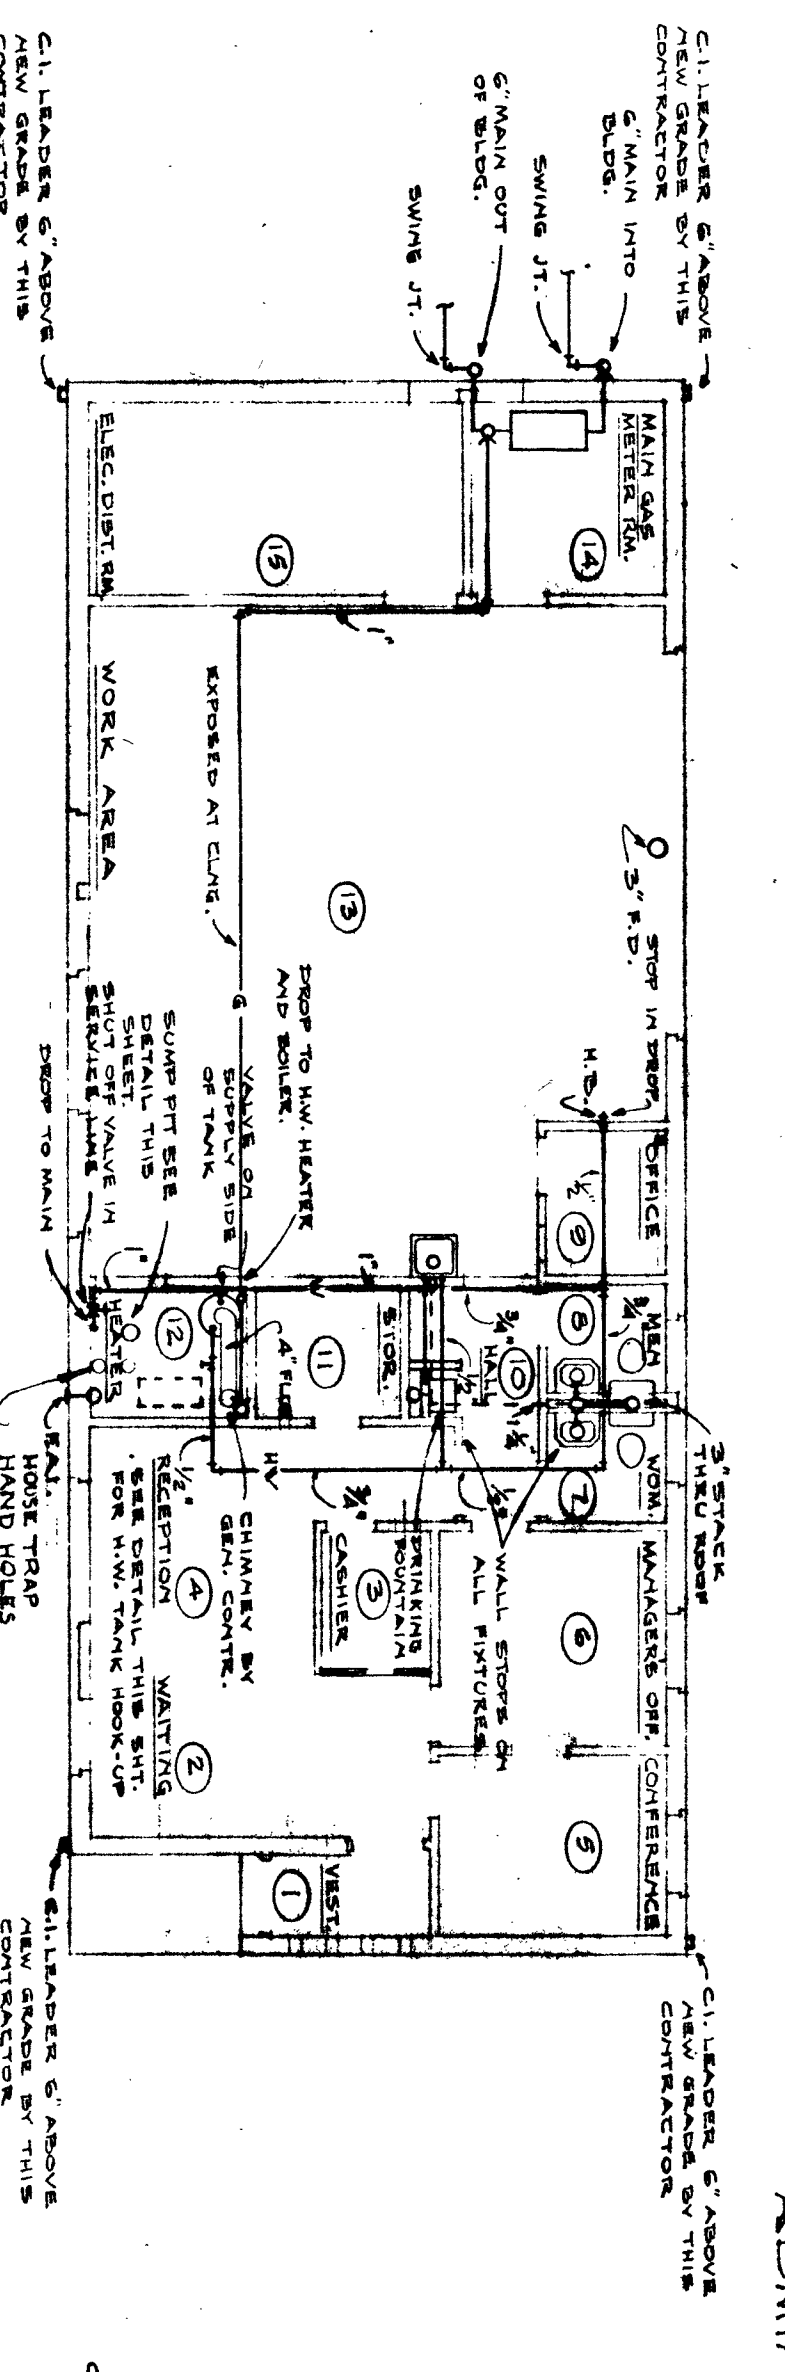

FIRST FLOOR PLAN
SCALE: 1/8" = 1'-0"

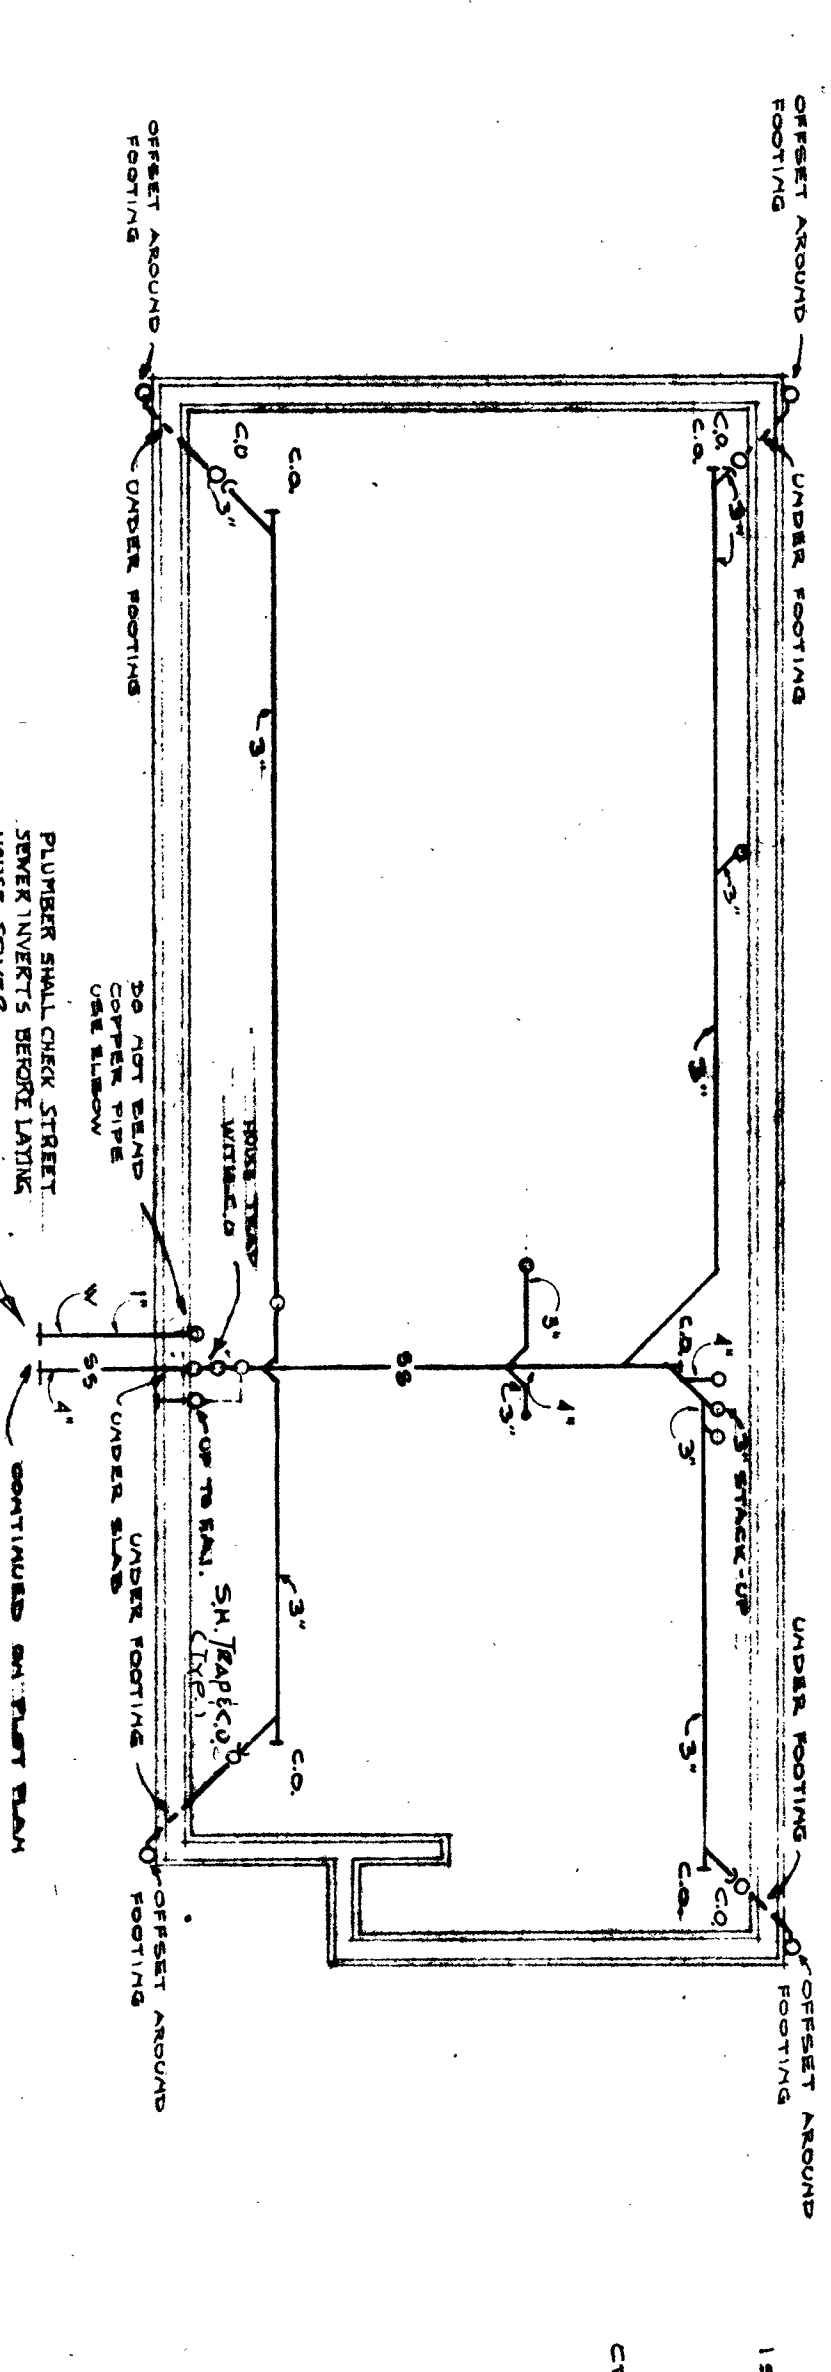


FOUNDATION PLAN
SCALE: 1/8" = 1'-0"

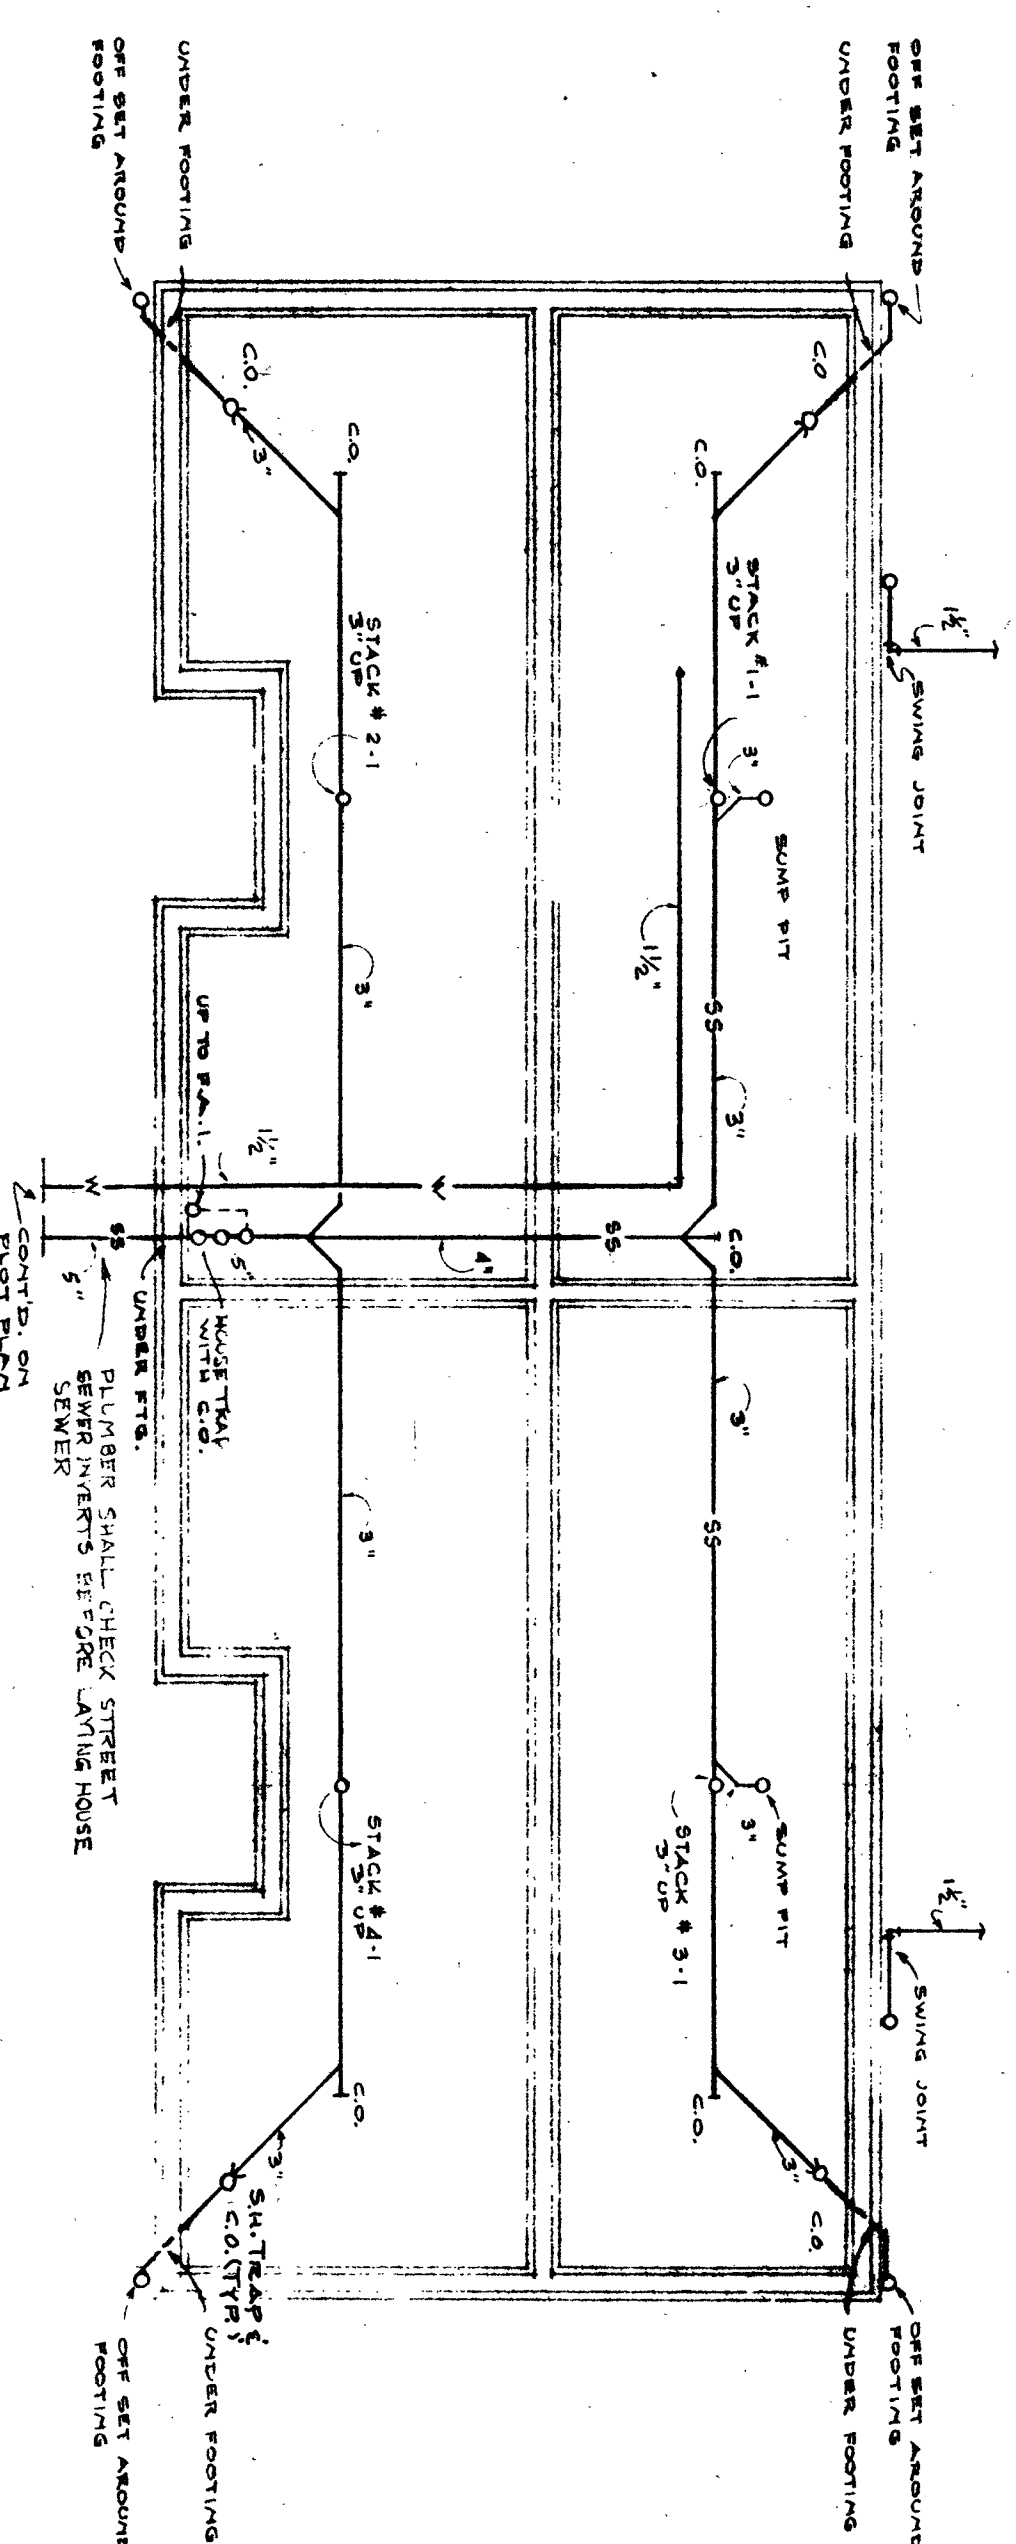


FOUNDATION PLAN
SCALE: 1/8" = 1'-0"

1 BEDROOM - 4 UNIT BLDG "A"
ADMINISTRATION BLDG.



TYP. SWAMP PIT DETAILS
NO SCALE

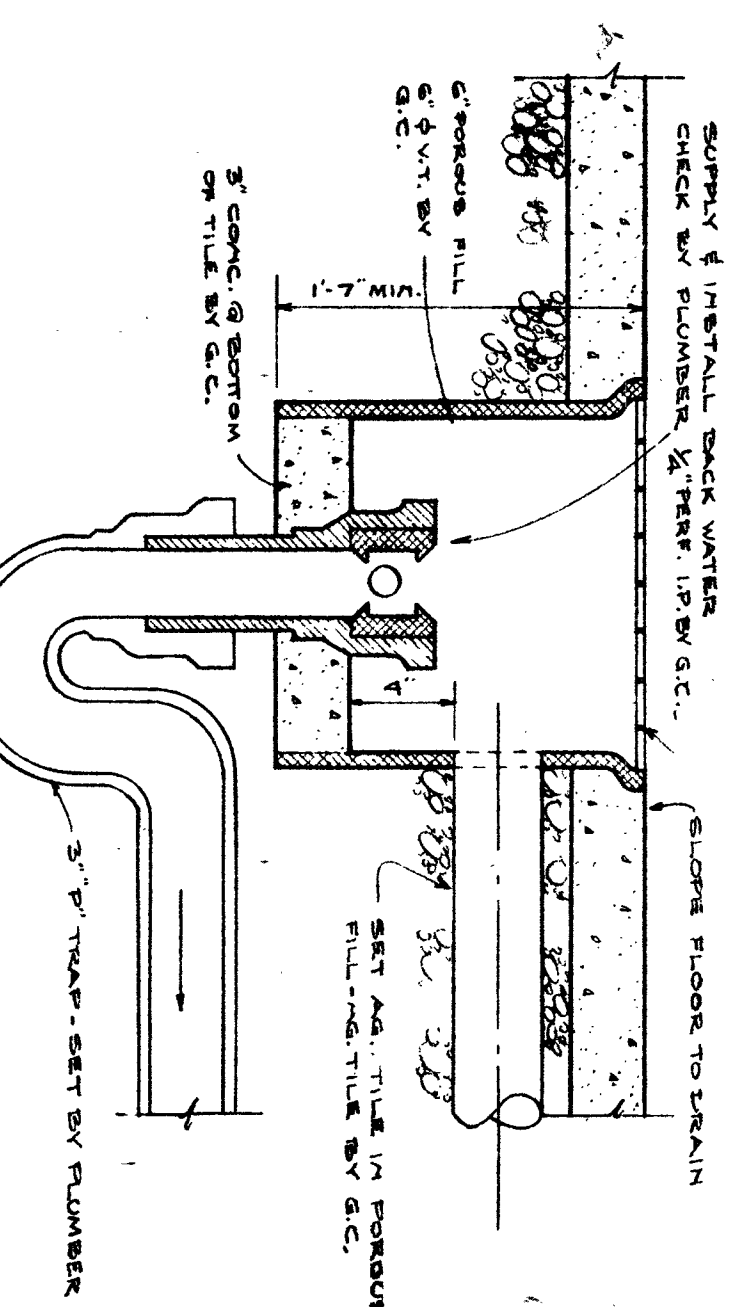


SCHEMATIC of GAS METER
BAR HOOK-UP
NO SCALE

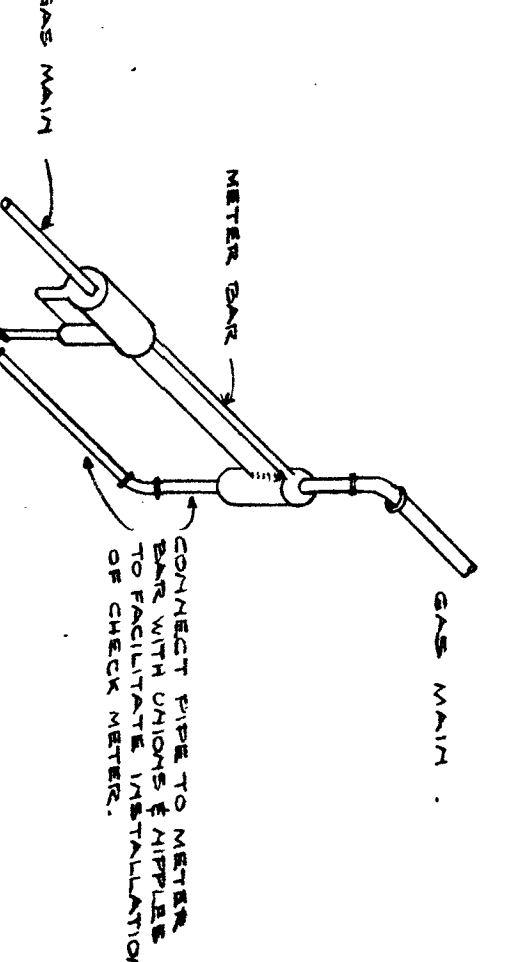


DETAIL of WATER & SEWER
IN ONE TRENCH
NO SCALE

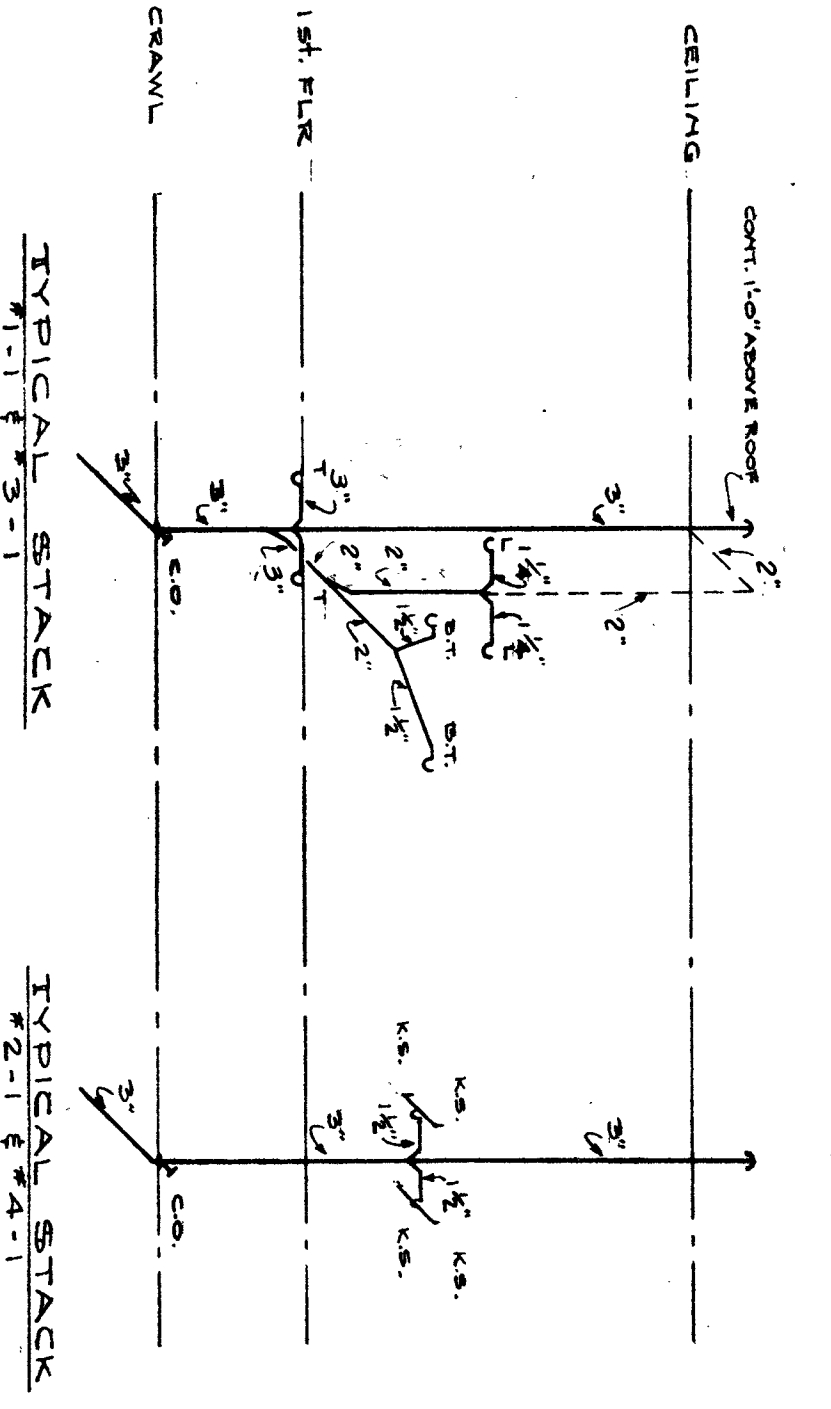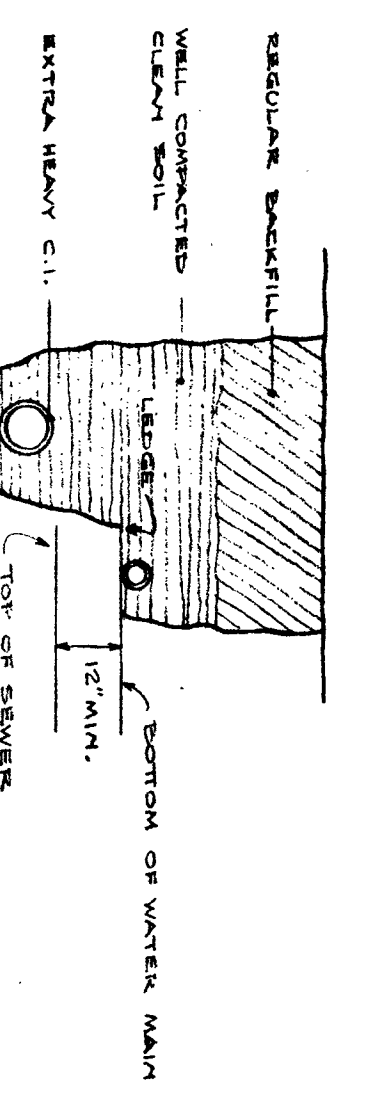


SCHEMATIC of DOMESTIC
HOT WATER GENERATOR
ADMINISTRATION BLDG.
NO SCALE

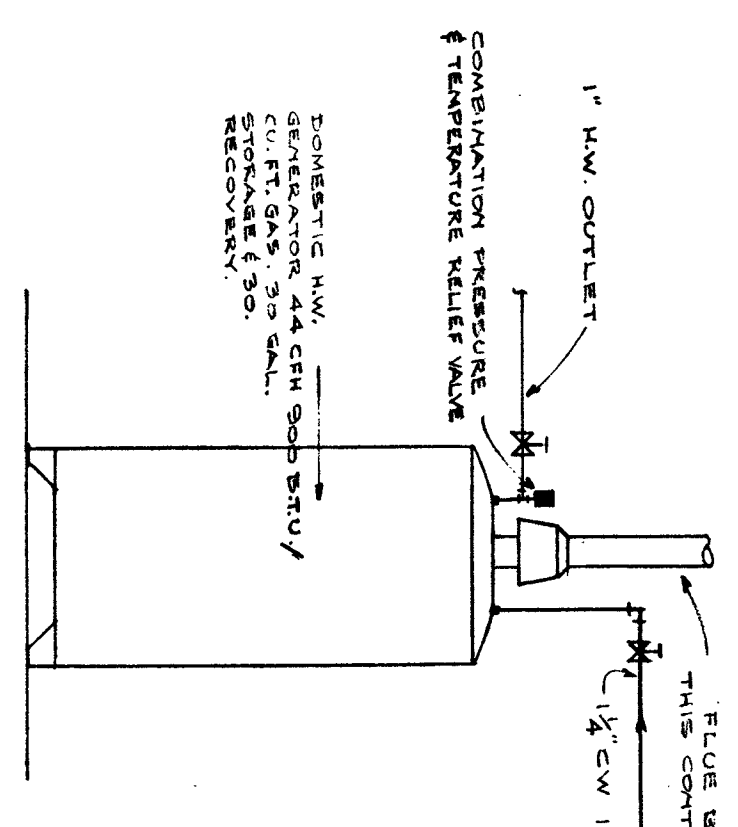


SCHEMATIC of DOMESTIC
HOT WATER GENERATOR
1 BEDROOM BLDG.
NO SCALE

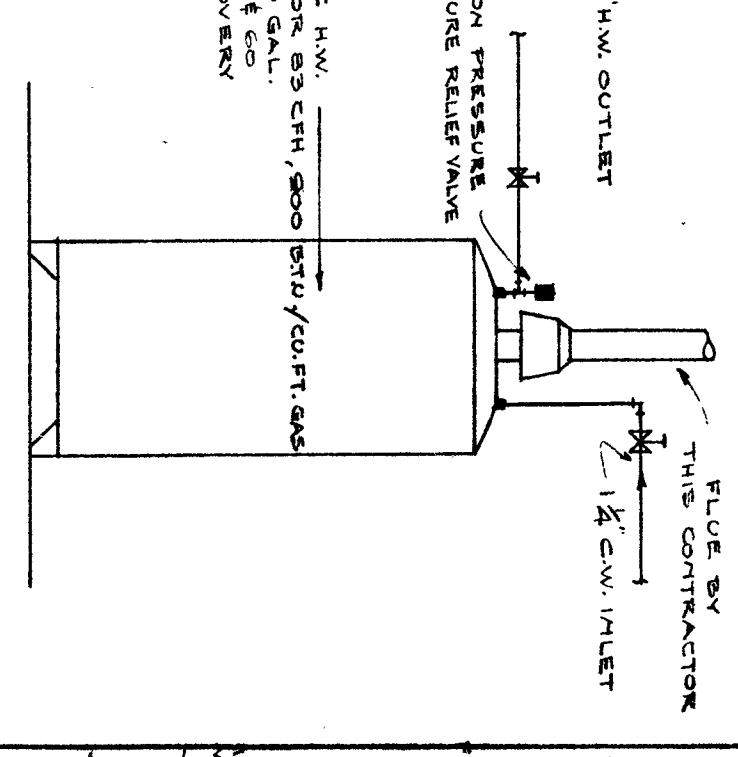

DETAIL of GAS MAIN
VENT AT BUILDING
ENTRANCE
NO SCALE

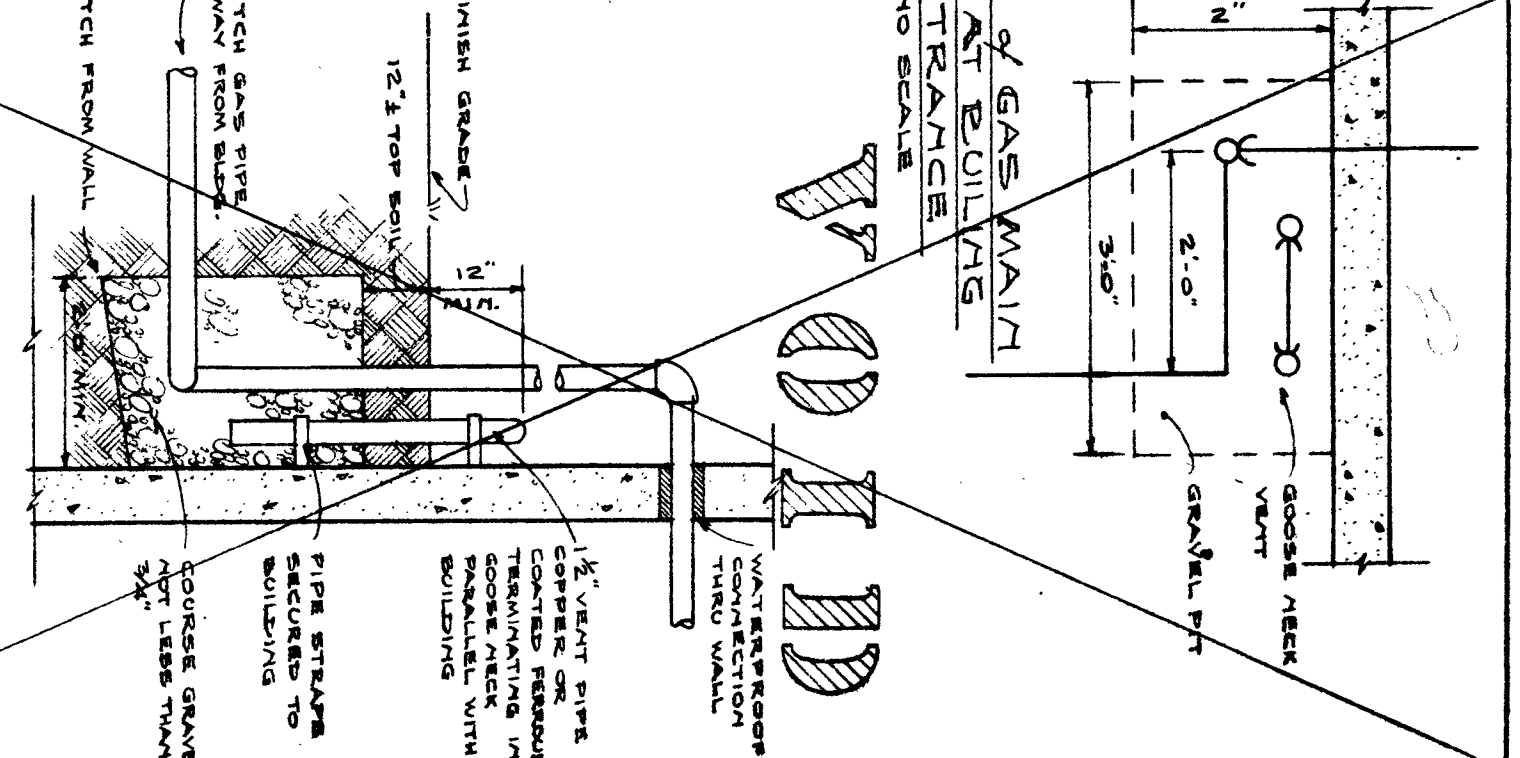

GENERAL NOTES:
1. CHECK SITE AND PLOT PLAN FOR EXACT LOCATION OF SURVEY POINTS.
2. SERVICE ENTRANCES: ENTER BACK OF BLDG. WHEN EXCAVATION ON SITE & PLOT PLANS.
3. COORDINATE WORK WITH HEATING CONTRACTOR AND GENERAL CONTRACTOR. ALL
LINES TO RUN PARALLEL WITH BUILDING LINES, EXCEPT AS NOTED.
4. VERIFY EXISTING UTILITIES AND RECORD FOR THE BEST OF MY KNOWLEDGE.

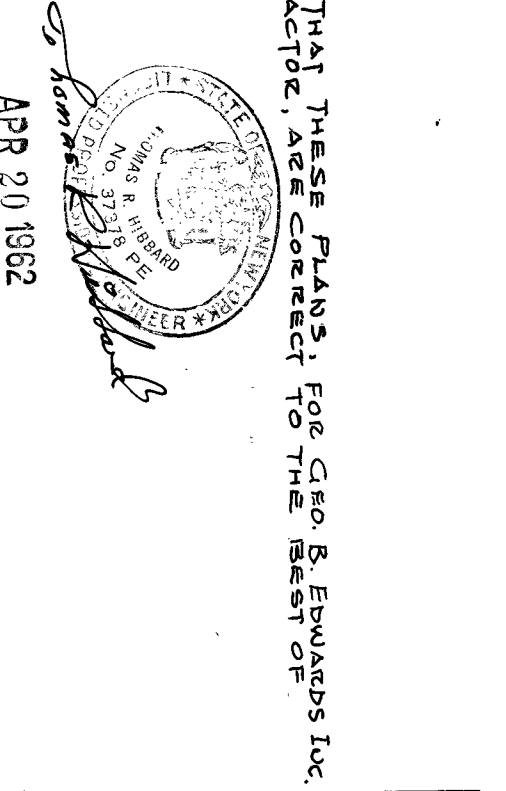

<p>100 UNITS LOW RENT HOUSING P.H.A. N.Y. II-2 FOR THE NIAGARA FALLS HOUSING AUTHORITY NIAGARA FALLS, NEW YORK</p> <p>SHACKLETON AND FITZGERALD, A.I.A. ARCHITECTS 1813 LOCKPORT STREET NIAGARA FALLS, N. Y.</p> <p>DATE: 5-16-60 JOB NO.: 50-147 DWG. NO.: P-200</p>	<p>D BLDG. 1-B. RM. UNIT & ADMIN. BLDG. DETS. SCALE: AS NOTED</p>
---	---

THE CONTRACTOR SHALL VERIFY ALL DIMENSIONS AT SITE BEFORE STARTING WORK