




SECOND FLOOR PLAN

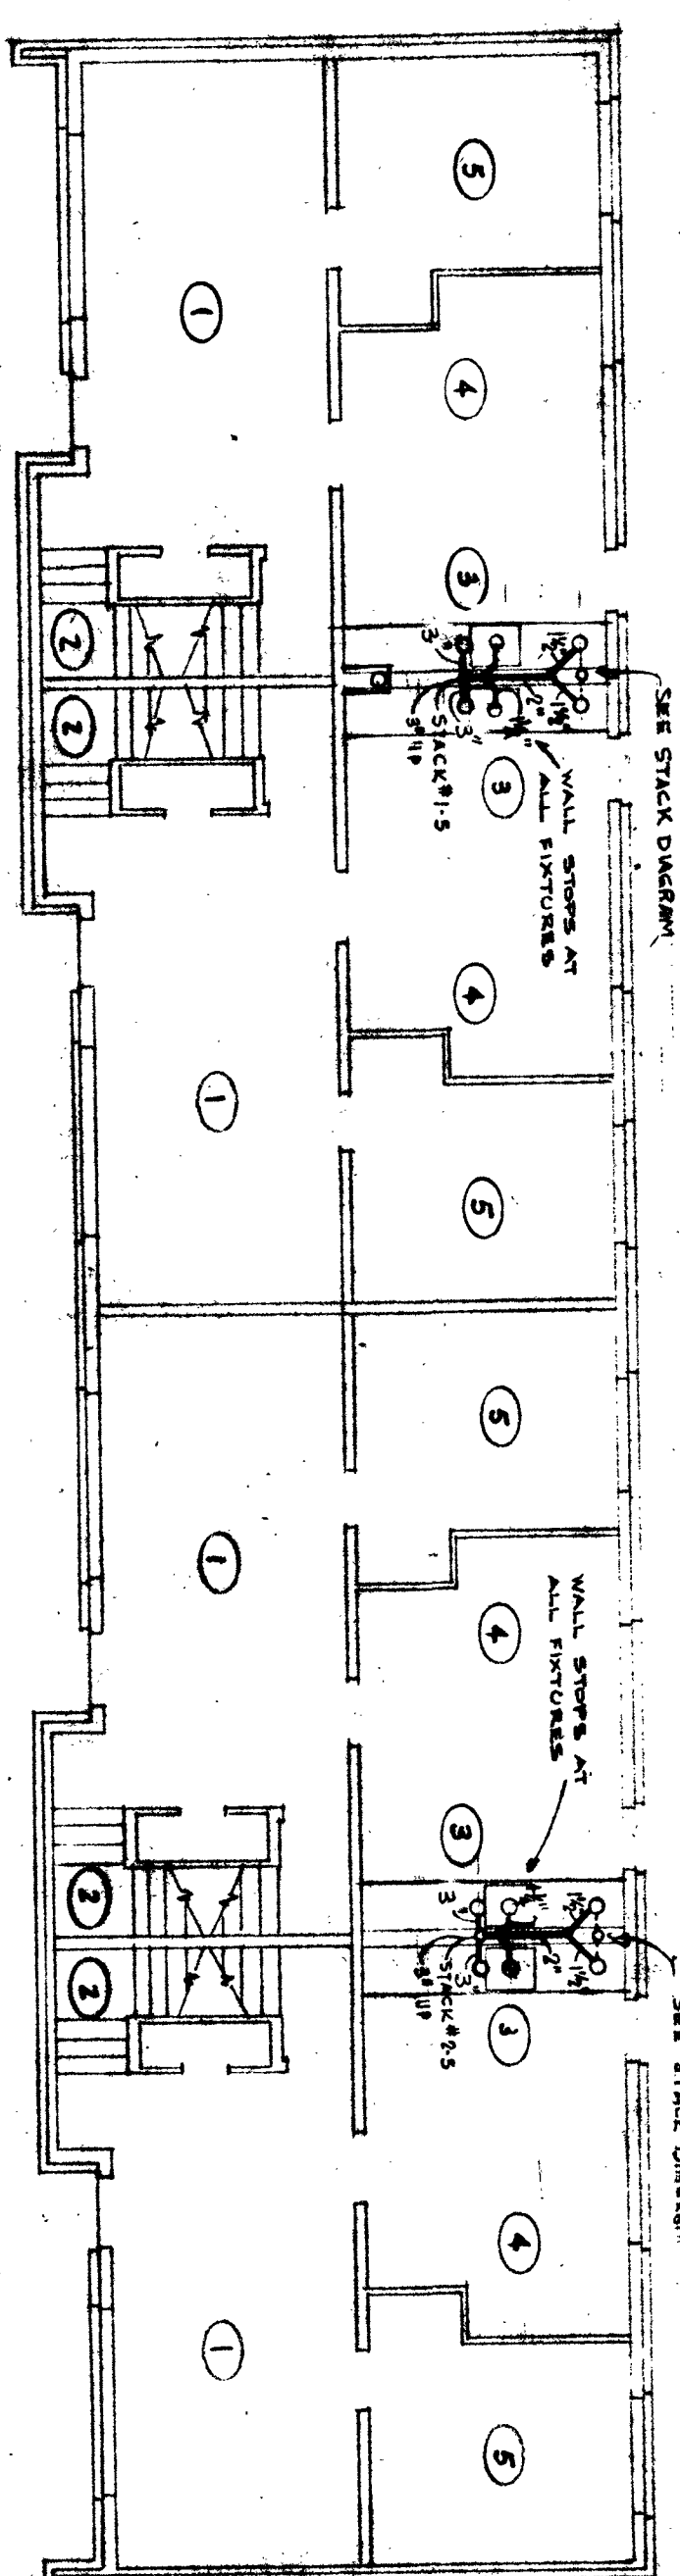

FIRST FLOOR PLAN

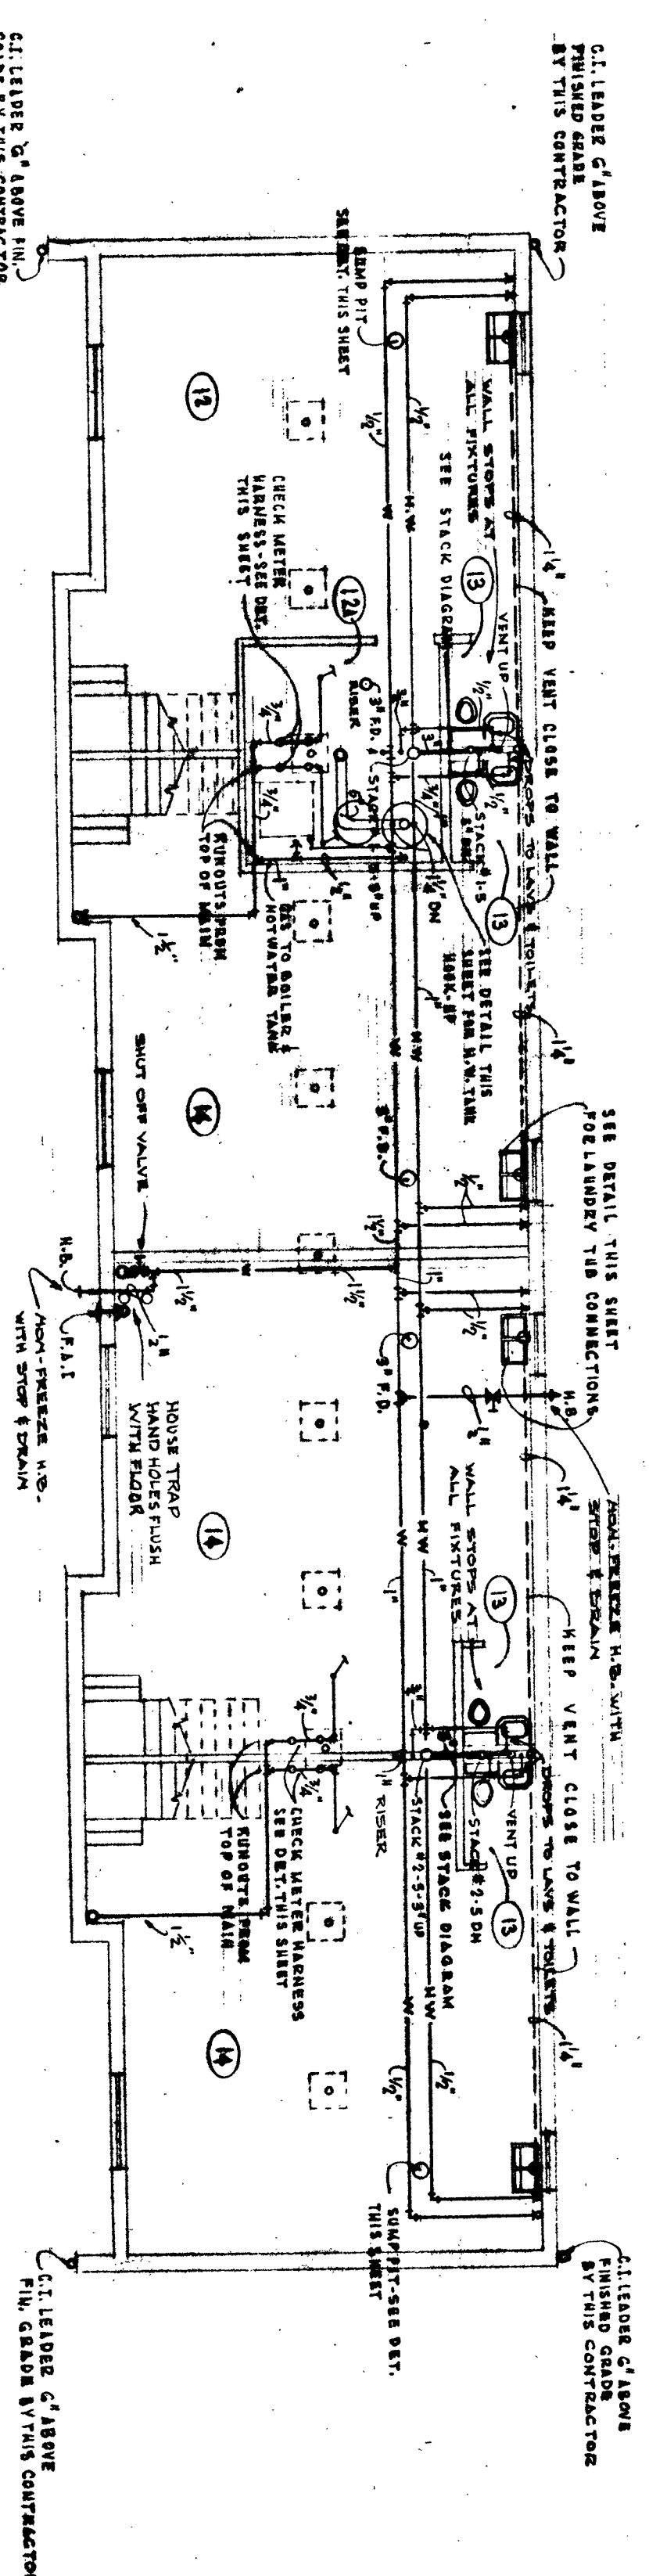


BASEMENT PLAN

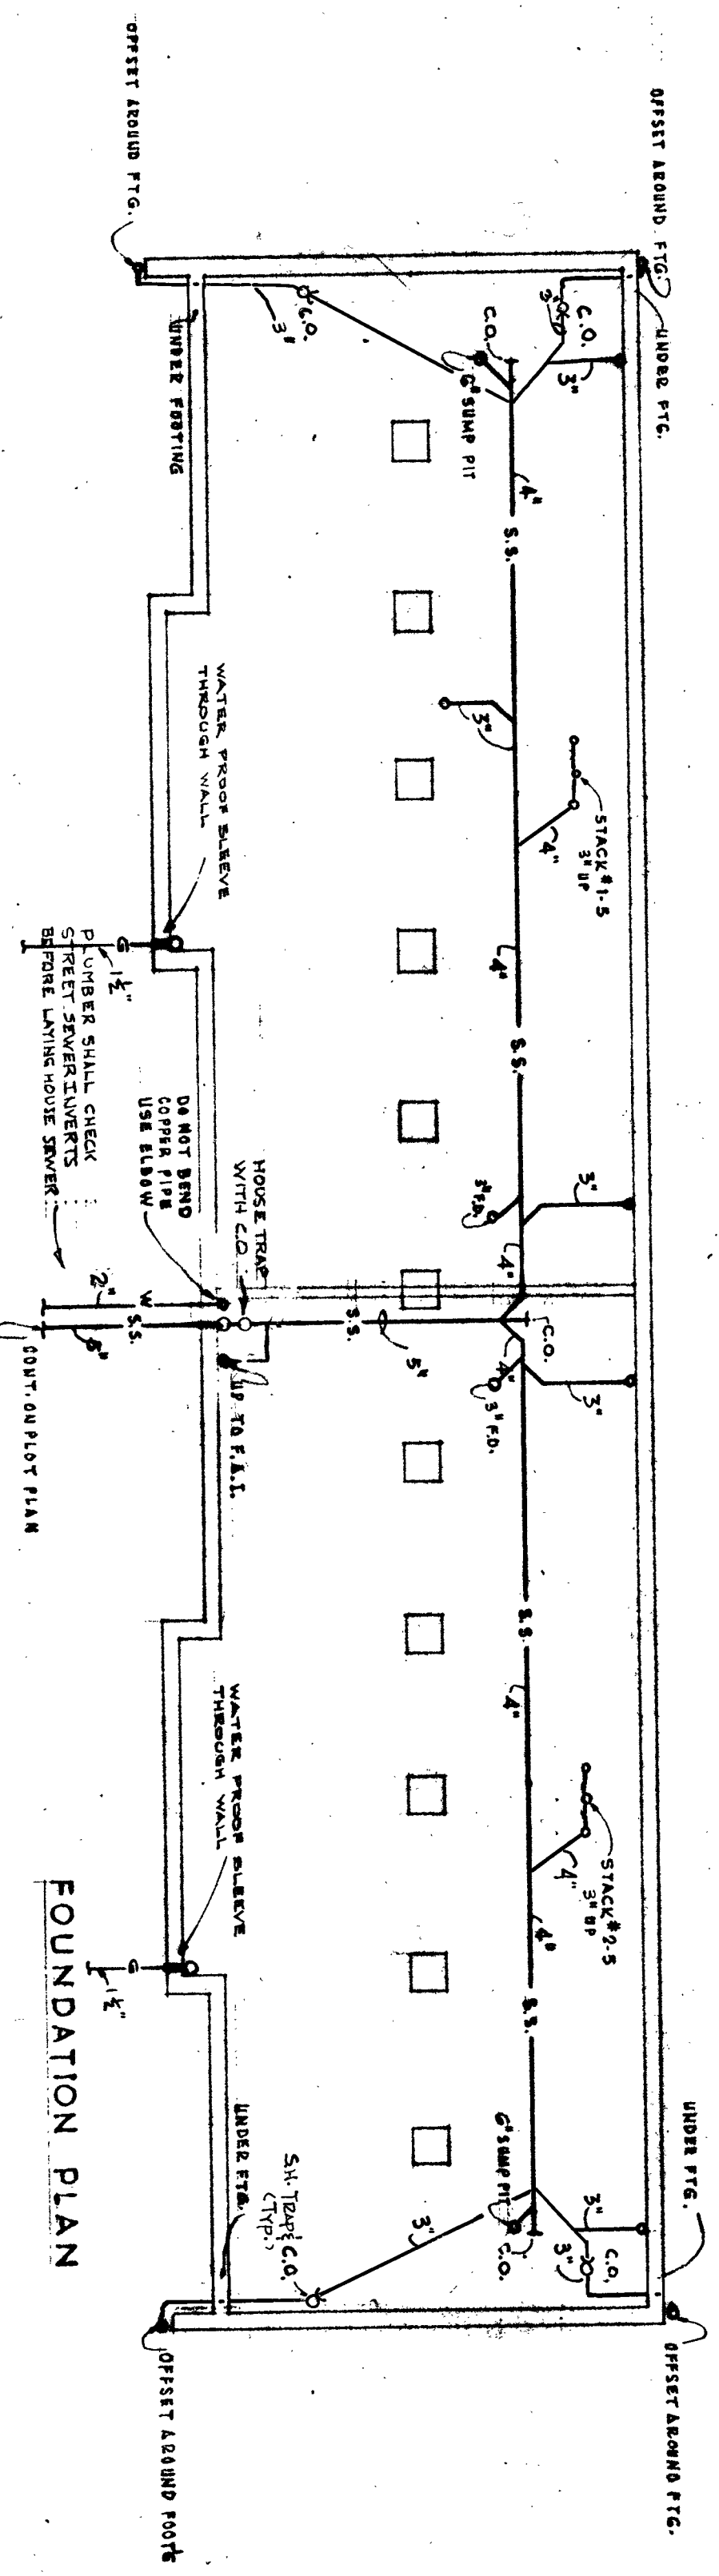


FOUNDATION PLAN


NOTES:
 1. CHECK SITE PLAN FOR EXACT LOCATION OF C.S. WATER, & GAS SERVICE ENTRANCE.
 2. CHECK BACK OF SHEET FOR SHOWN ON SITE & IN FIELD.
 3. SHOW DIMENSIONS TO SUBPARALLEL WITH BUILDING UNLESS OTHERWISE SPECIFIED.

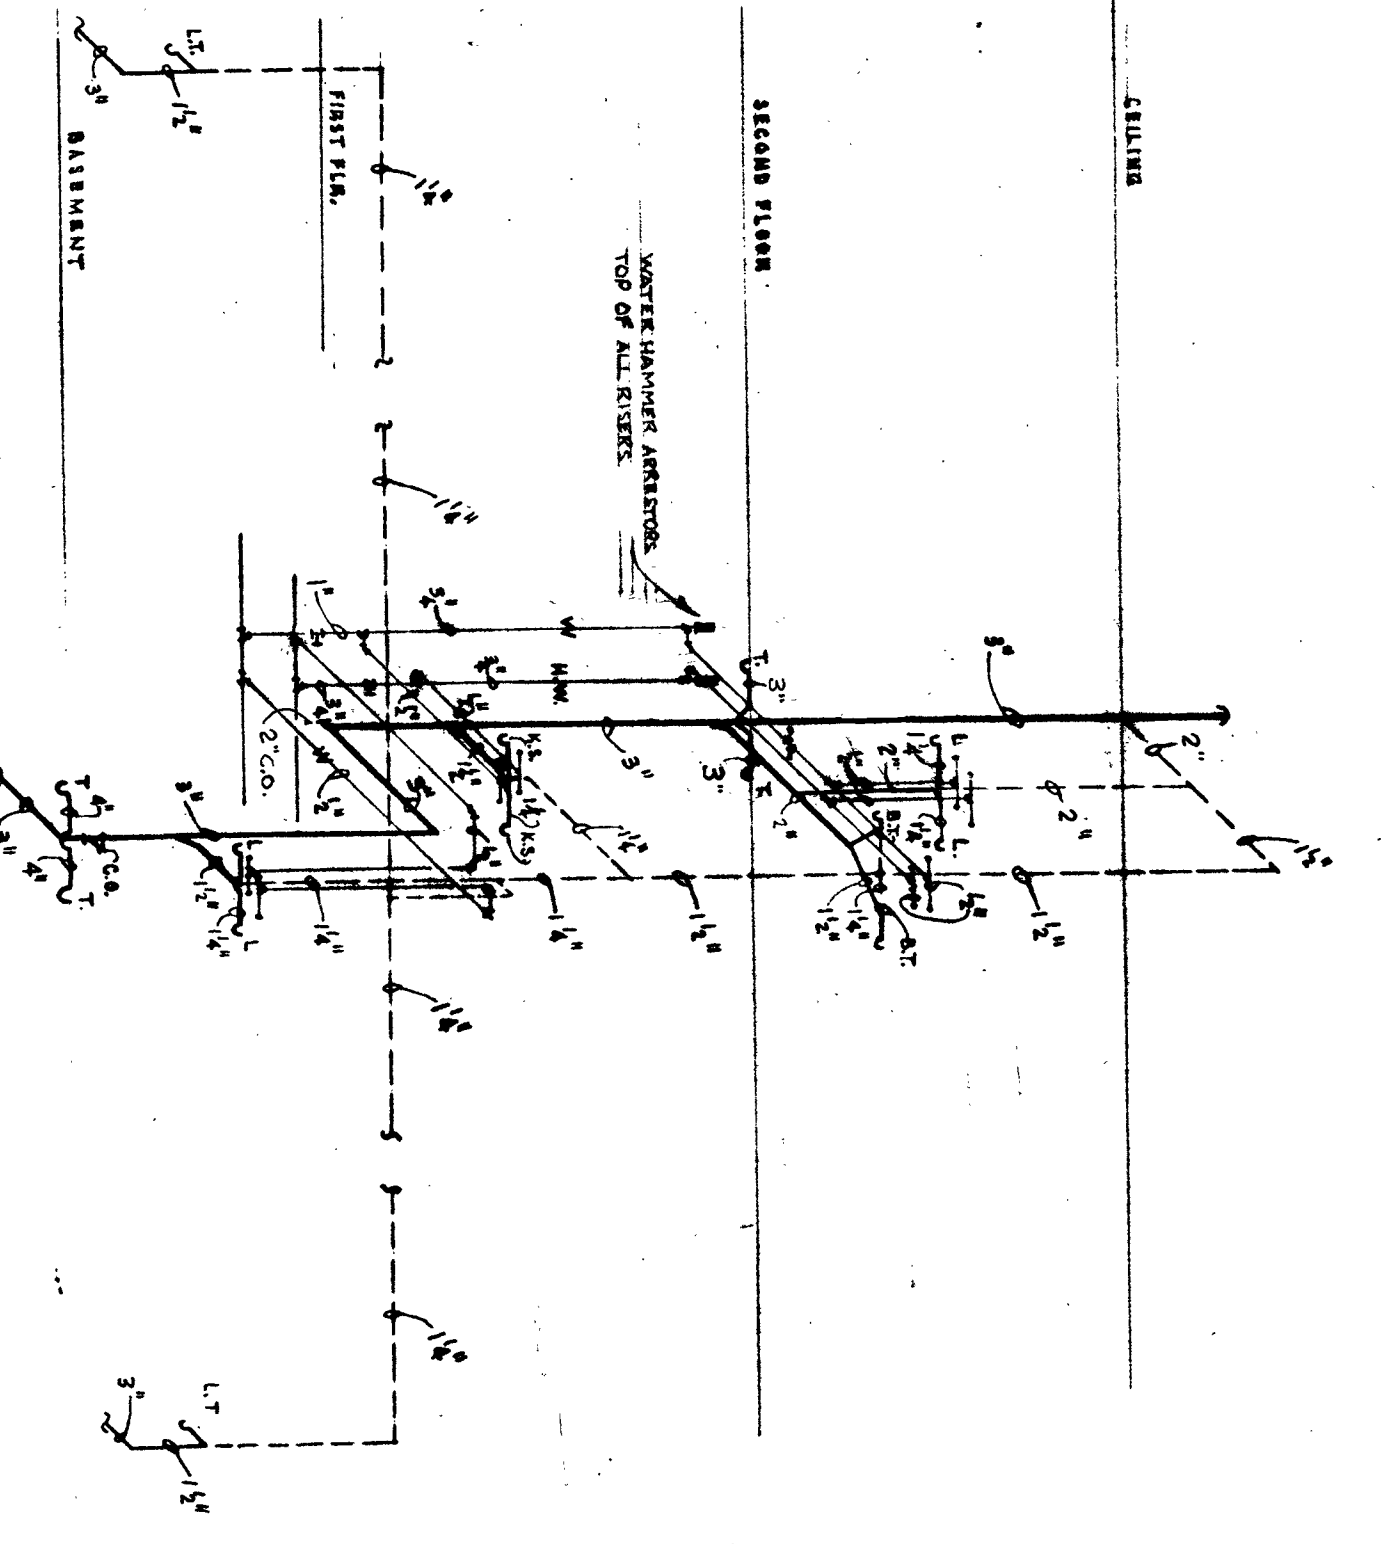


STACK DIAGRAM 1-5 & 2-5 NO SCALE

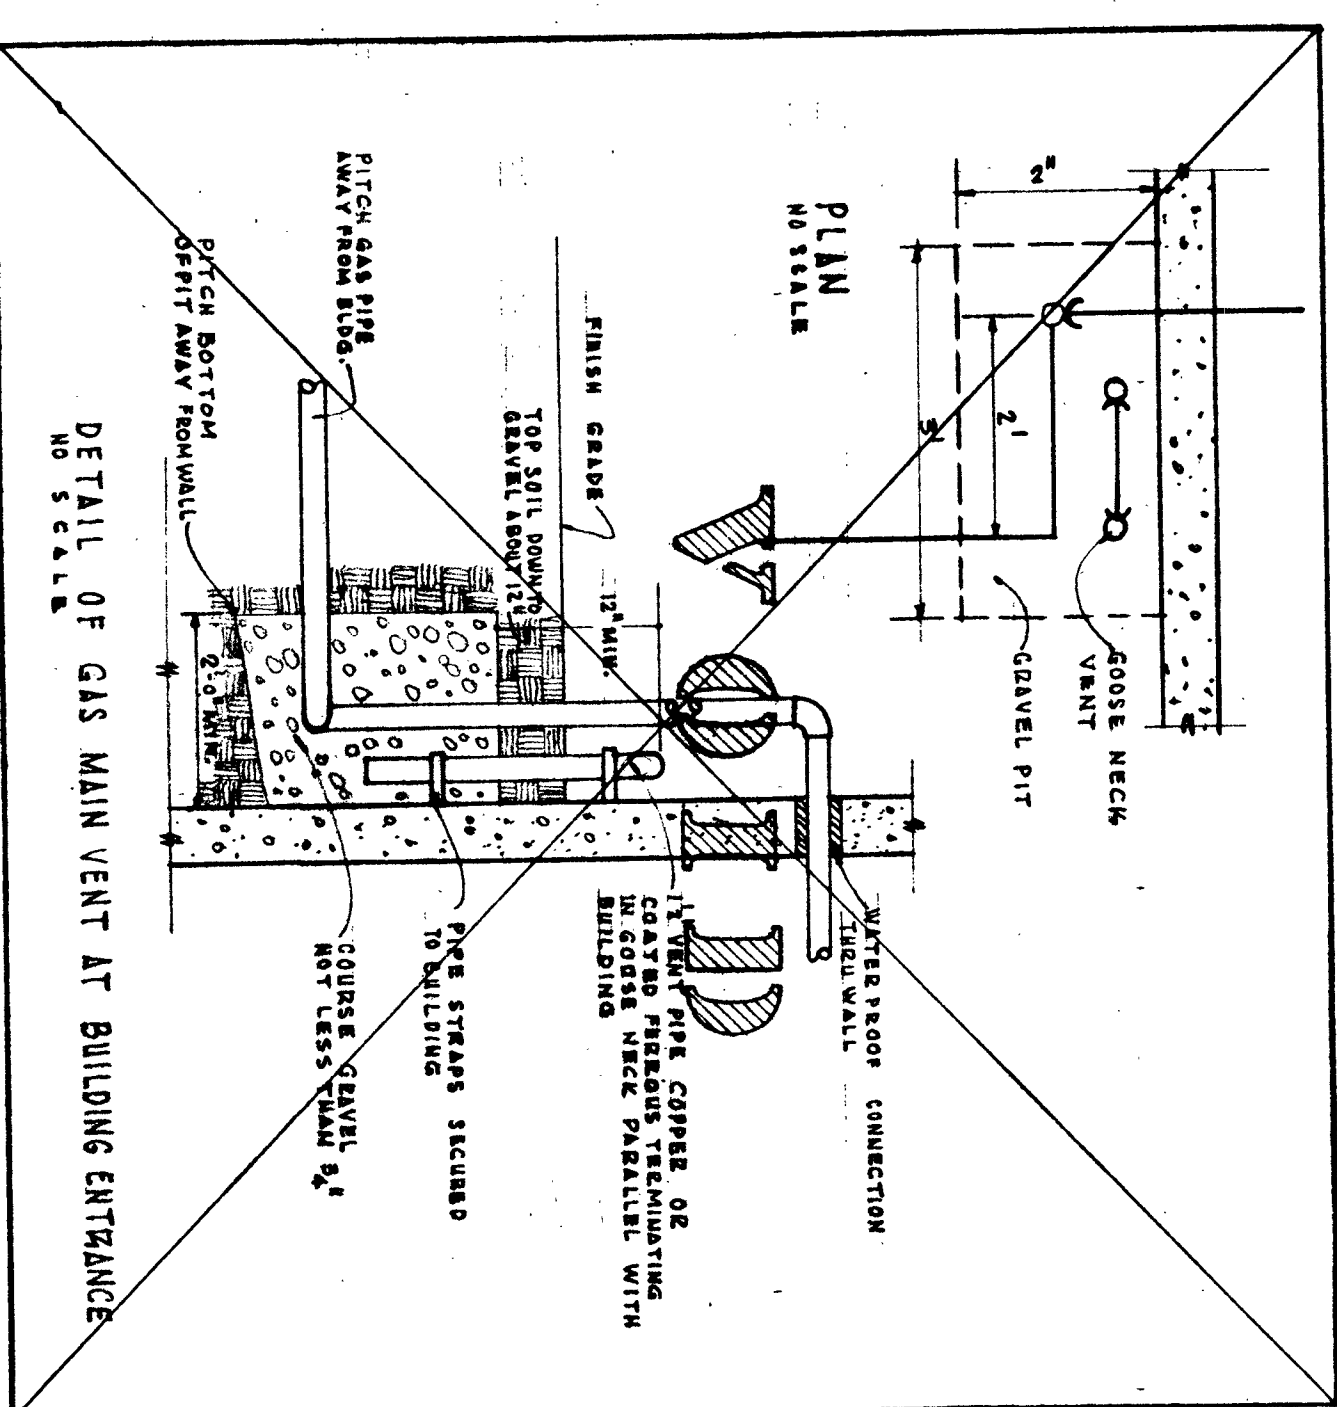


DETAIL OF GAS MAIN VENT AT BUILDING ENTRANCE NO SCALE

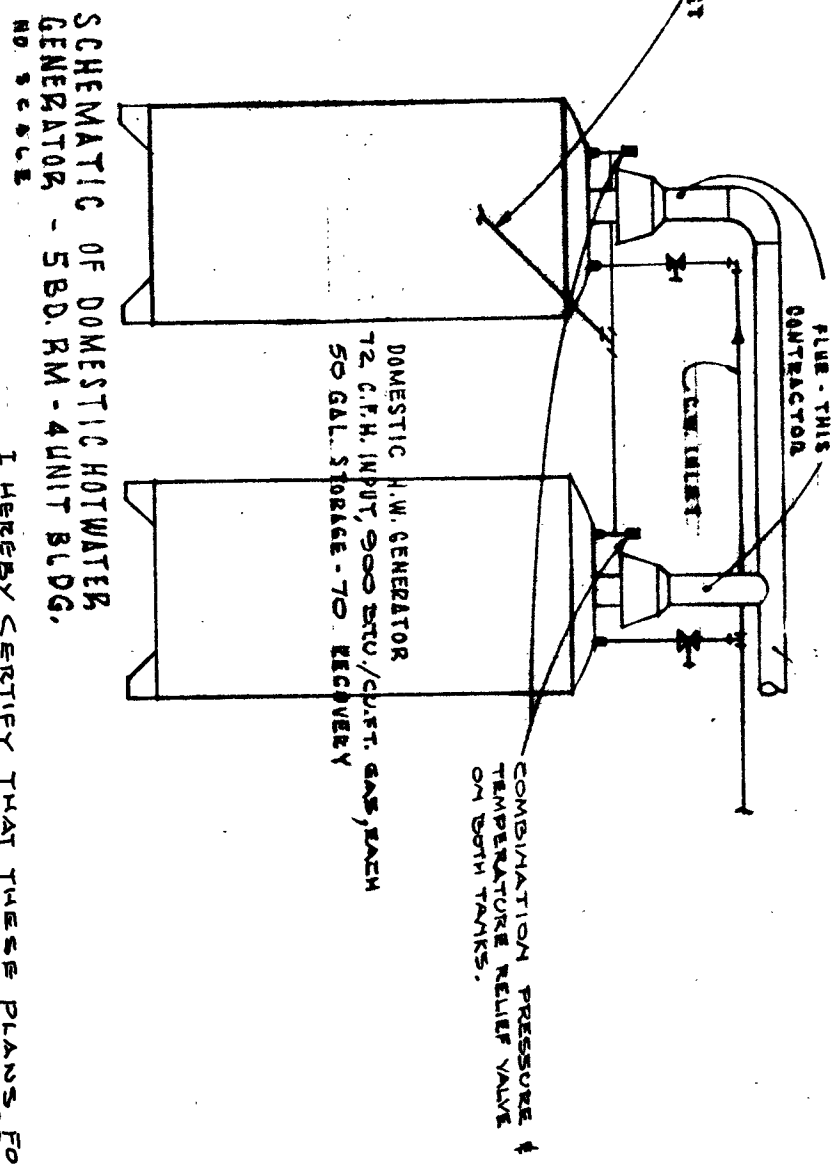


SCHEMATIC OF DOMESTIC HOT WATER GENERATOR - 550 RM - 4 UNIT BLDG. NO SCALE

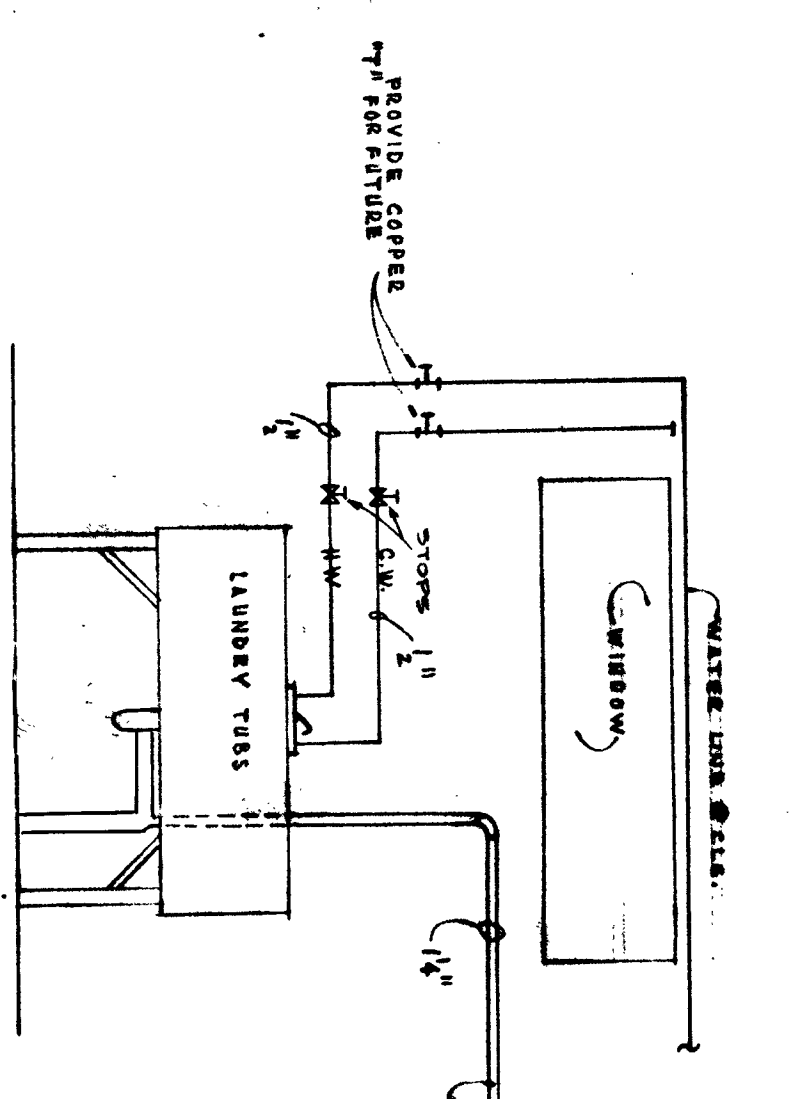


DETAIL OF LAUNDRY TUB CONNECTIONS NO SCALE

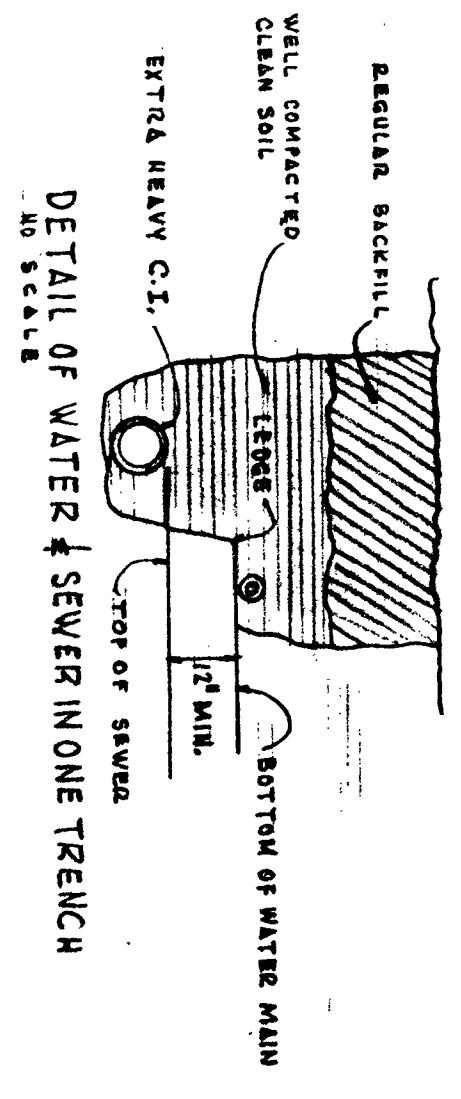

DETAIL OF WATER & SEWER IN ONE TRENCH NO SCALE

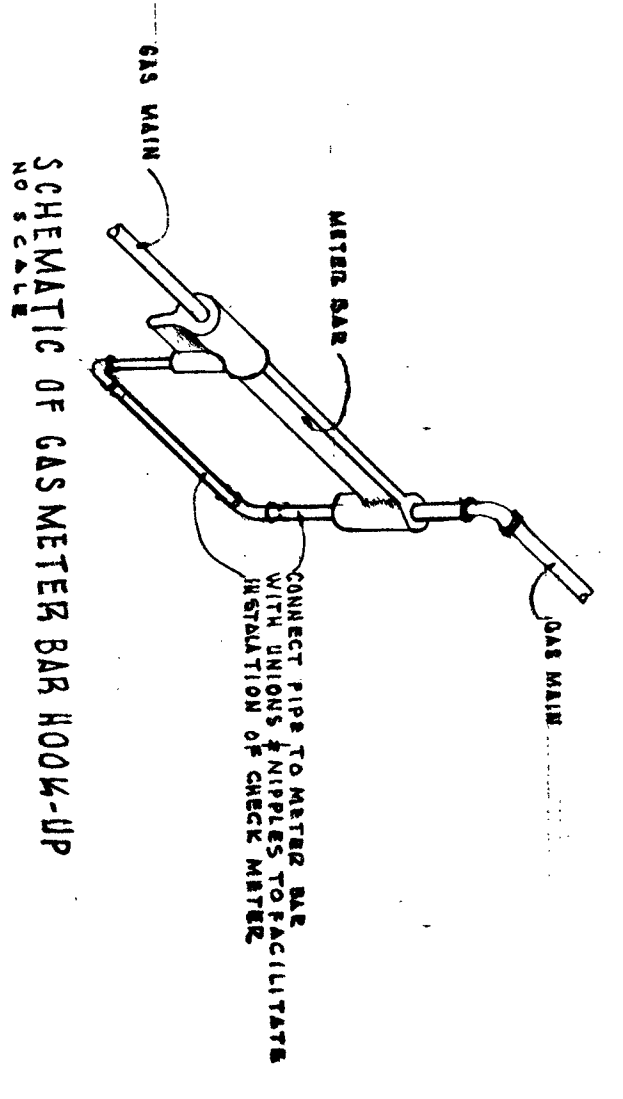

SCHEMATIC OF GAS METER BAR HOOK-UP NO SCALE

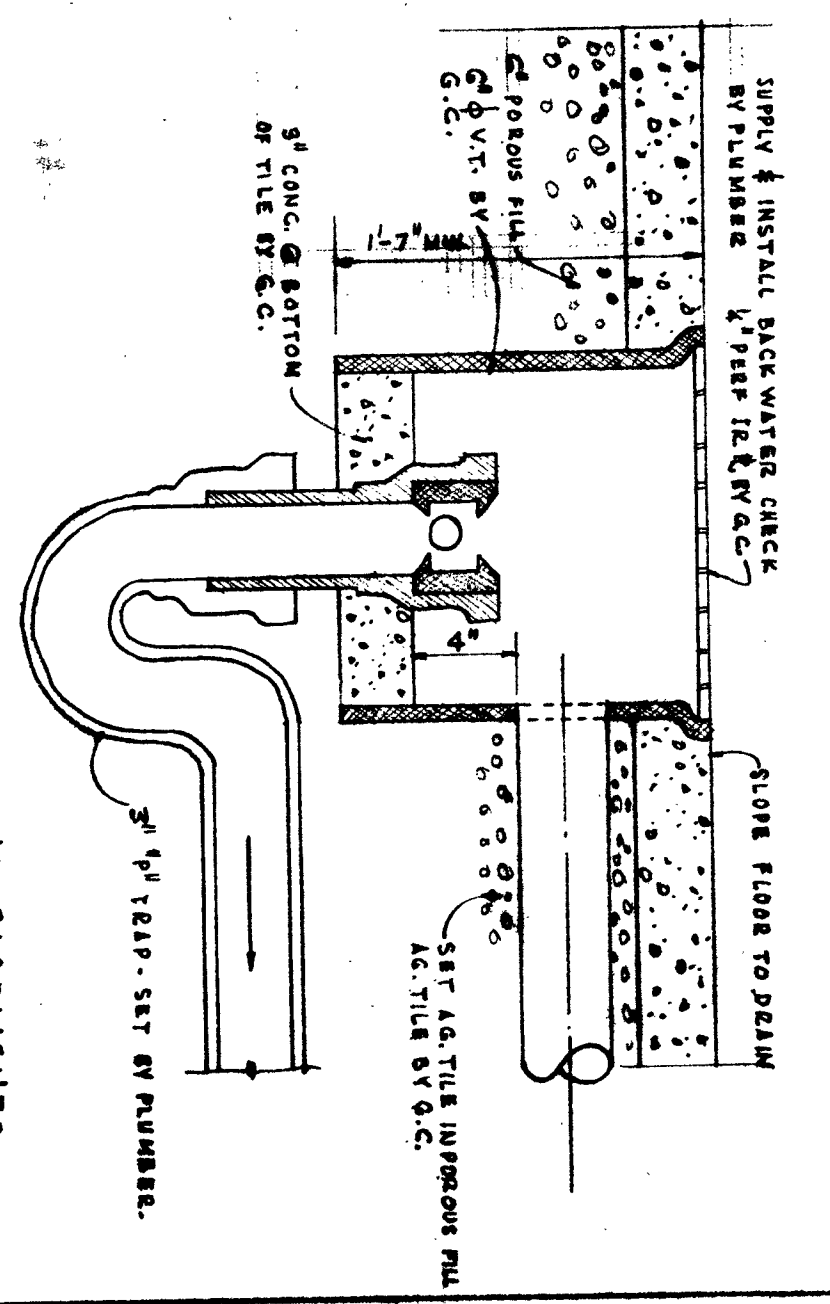

SUMP PIT DETAIL @ END BASEMENTS @ ALL SIZES NO SCALE

REGISTERED ARCHITECT
 JOHN W. FITZGERALD
 1513 LOCKPORT STREET
 NIAGARA FALLS, N. Y.
 P. 20 1932

	C. BLDG. SECT. UNIT & MISC. DETAILS 100 UNITS LOW RENT HOUSING R. H. A. N. Y. II-2 FOR THE NIAGARA FALLS HOUSING AUTHORITY NIAGARA FALLS SHACKLETON AND FITZGERALD, A.I.A. ARCHITECTS 1513 LOCKPORT STREET NIAGARA FALLS, N. Y.	SCALE AS NOTED JOB NO. 50-147 DATE 5-11-60 DWG. NO. P-203
--	---	--