


TYPICAL WATER SERVICE DETAIL
NOT TO SCALE

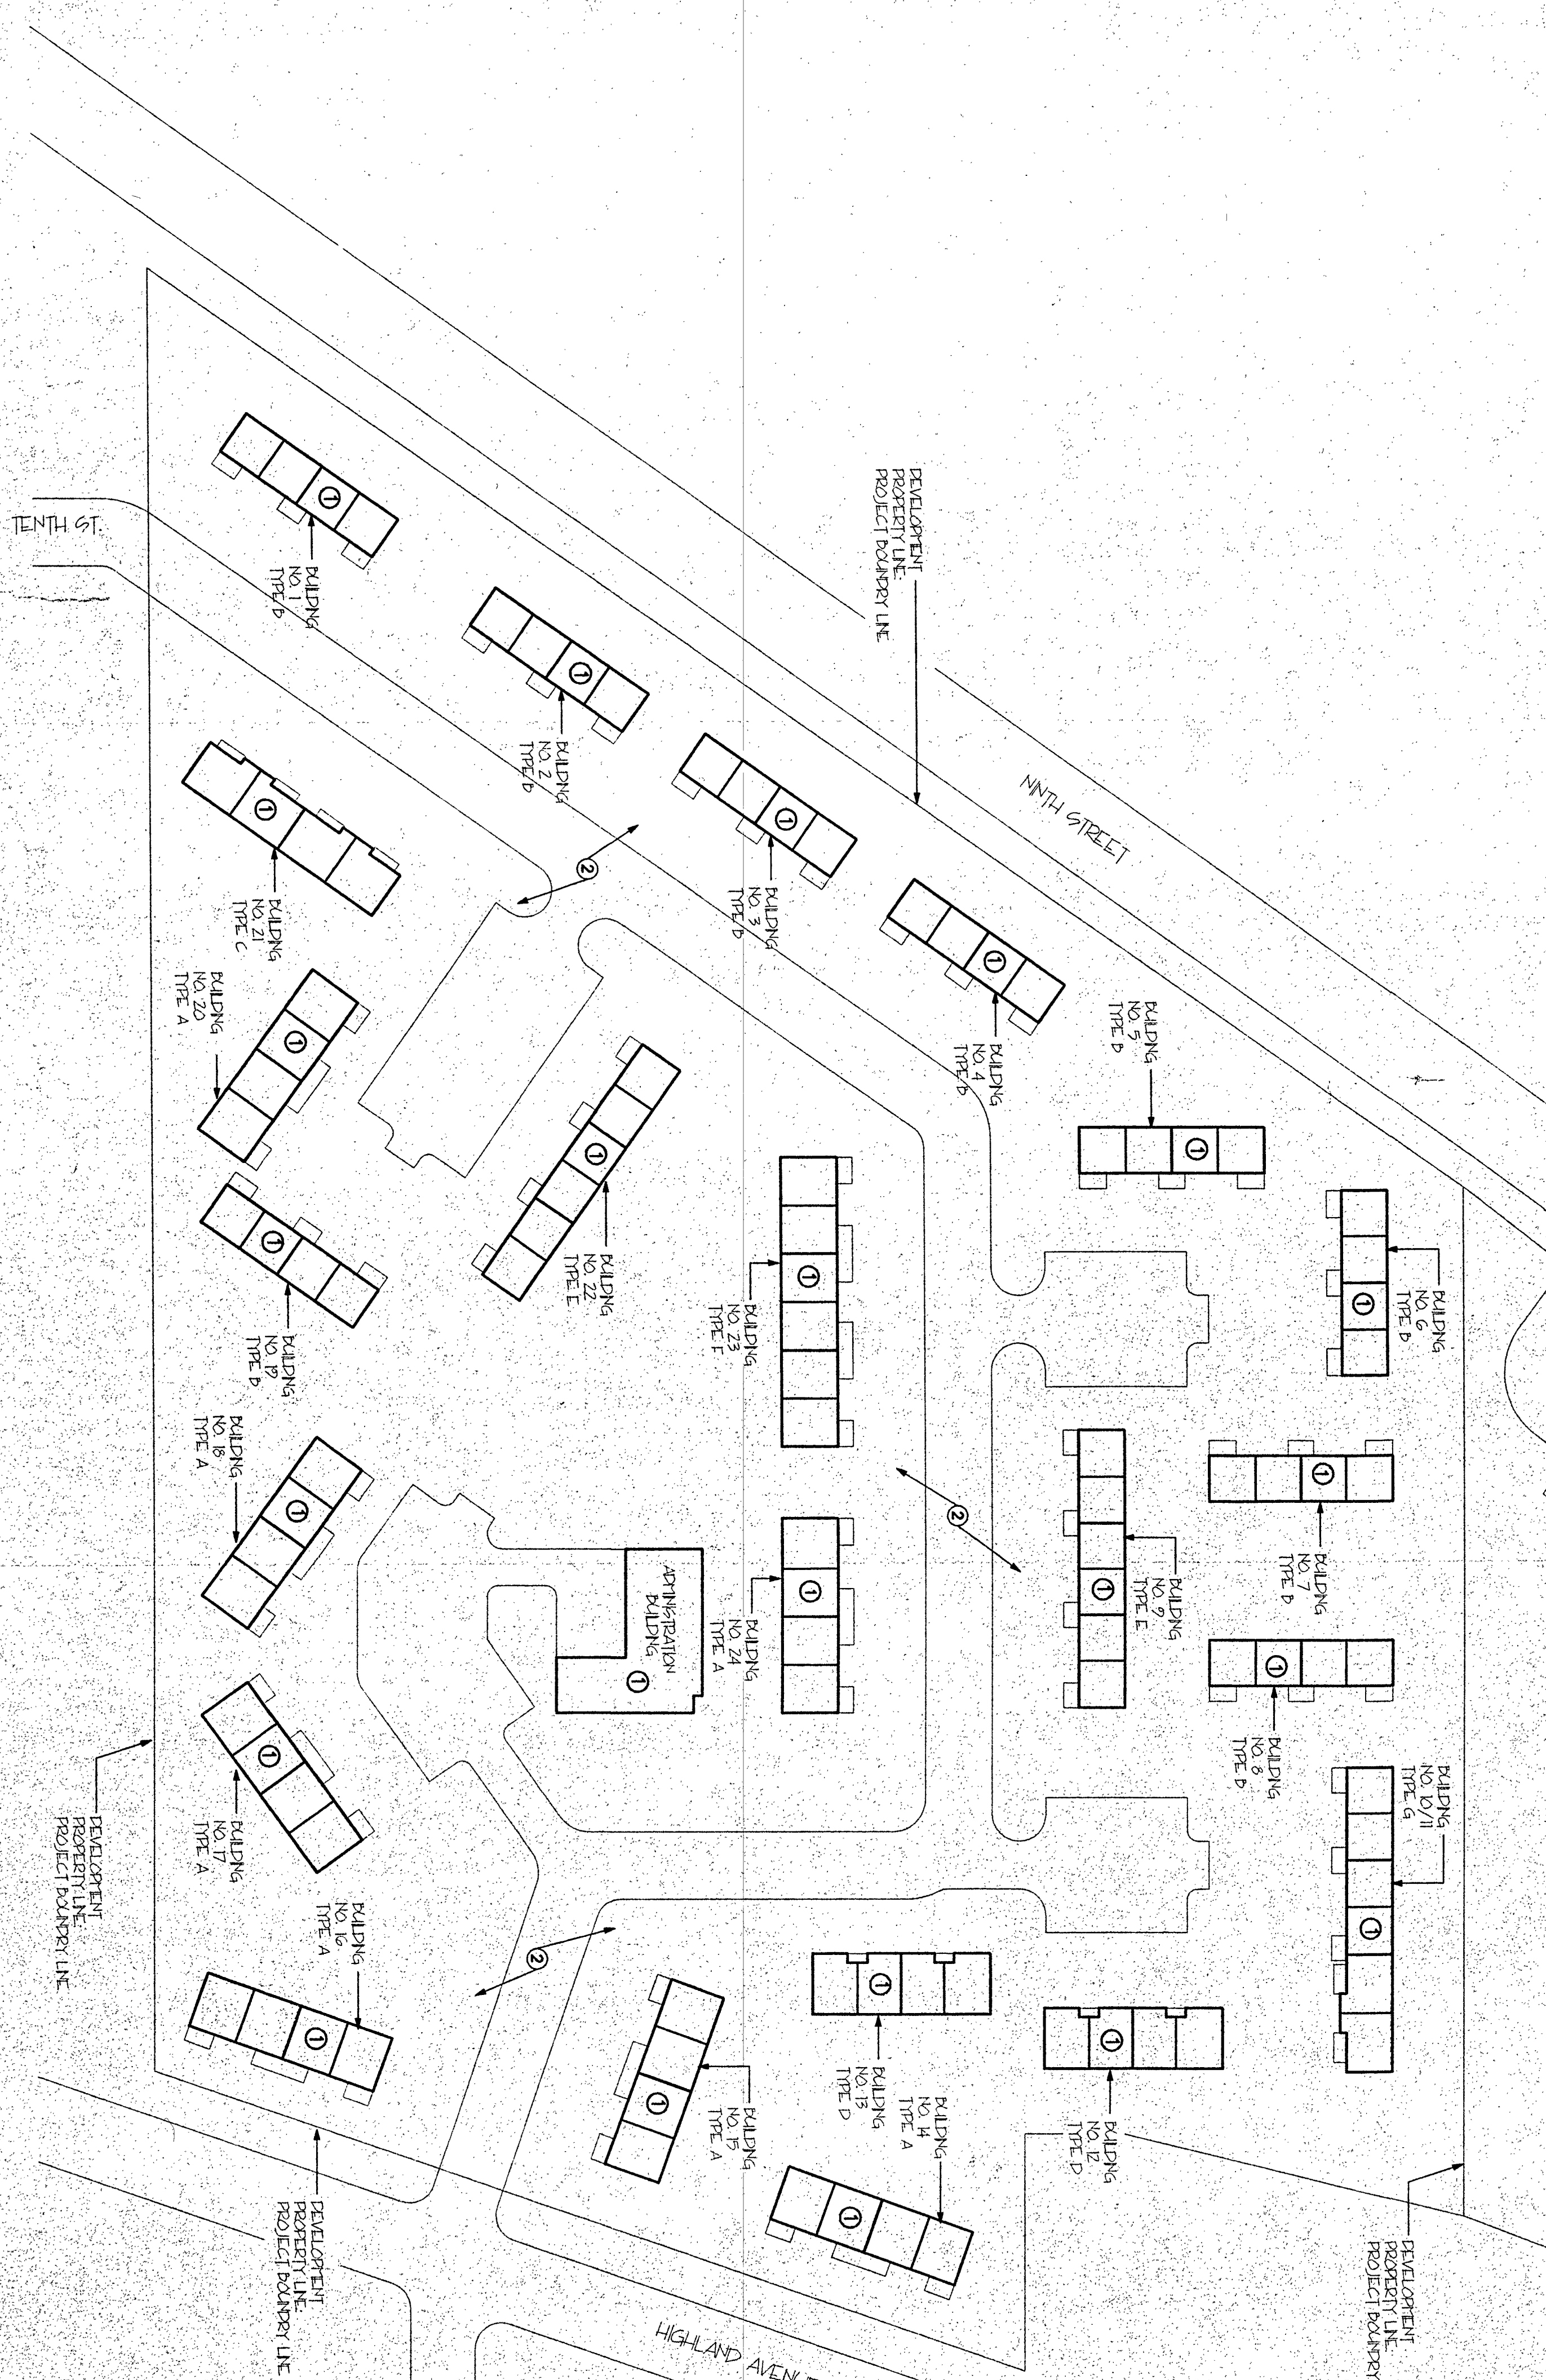

SITE PLAN
SCALE 1" = 50'

PLUMBING SYMBOL LIST	
SYMBOL	DESCRIPTION
	POINT OF CONNECTION
	POINT OF DISCONNECTION
	EXISTING COLD WATER PIPING (CW)
	SHUT OFF VALVE

- DRAWING NOTES:**
- DISCONNECT AND REMOVE EXISTING 1 1/2" GATE SHUT-OFF VALVE FROM EXISTING BASEMENT AT EACH BUILDING PROVIDE NEW 1 1/2" SHUT-OFF VALVES PIPING ADAPTORS, ETC. AS SPECIFIED AND REQUIRED.
 - PLUMBING CONTRACTOR SHALL SCHEDULE BUILDING WATER SERVICE SHUTDOWNS WITH OWNERS REPRESENTATIVE AS REQUIRED TO COMPLETE THE SCOPE OF WORK.

RECORD DRAWING

Drawing Attention: The following is an excerpt from the New York State Education Law Article 143 section 209 and opens to this drawing: It is a violation of this law for any person, unless acting under the direction of a licensed architect or licensed Professional Engineer to alter or tamper with the seal of an architect or engineer shall after the seal and date the motion allowed by, followed by the signature and date of such alteration and a specific description of the alteration.

<p>Scale: AS NOTED</p> <p>Date: 08/01/02</p> <p>Drawn By: PLS/KLB</p> <p>Checked By: PRO/JGR</p> <p>Sheet: P101</p>	<p>PROJECT 2 - IMPROVEMENTS TO VARIOUS LOW RISE DEVELOPMENTS</p> <p>HARRY JORDON GARDENS - SITE PLAN - PLUMBING</p> <p>ARCHITECTURAL REPAIRS AND IMPROVEMENTS PROGRAM YEARS 2001-2002 CAPITAL FUND</p> <p>NIAGARA FALLS HOUSING AUTHORITY PROJECT NO. 02-21-CAP</p> <p>NIAGARA FALLS HOUSING AUTHORITY 744 TENTH STREET NIAGARA FALLS, NEW YORK 14301</p>	<p>Architect:</p> <p>Architecture Unlimited</p> <p>Phone: 716-692-1944 15 Webster Street North Tonawanda, New York 14120</p>	<p>Consultant:</p> <p>ME ENGINEERING P.C.</p> <p><small>MECHANICAL/ELECTRICAL/ENGINEERING CONSULTANTS</small></p> <p>WATERFRONT VILLAGE CENTER SUITE 300 60 LAKEFRONT BOULEVARD BUFFALO, NY 14202 716-645-2200 FAX 716-645-6187 ME JOB #05252</p>	<p><small>Notice: No part of this drawing may be reproduced, stored in a retrieval system, or transmitted in any form or by any means, electronic, mechanical, photocopying, recording, or otherwise, without the prior written consent of the Architectural Consultant.</small></p> <p>Scale:</p>
---	--	---	--	--